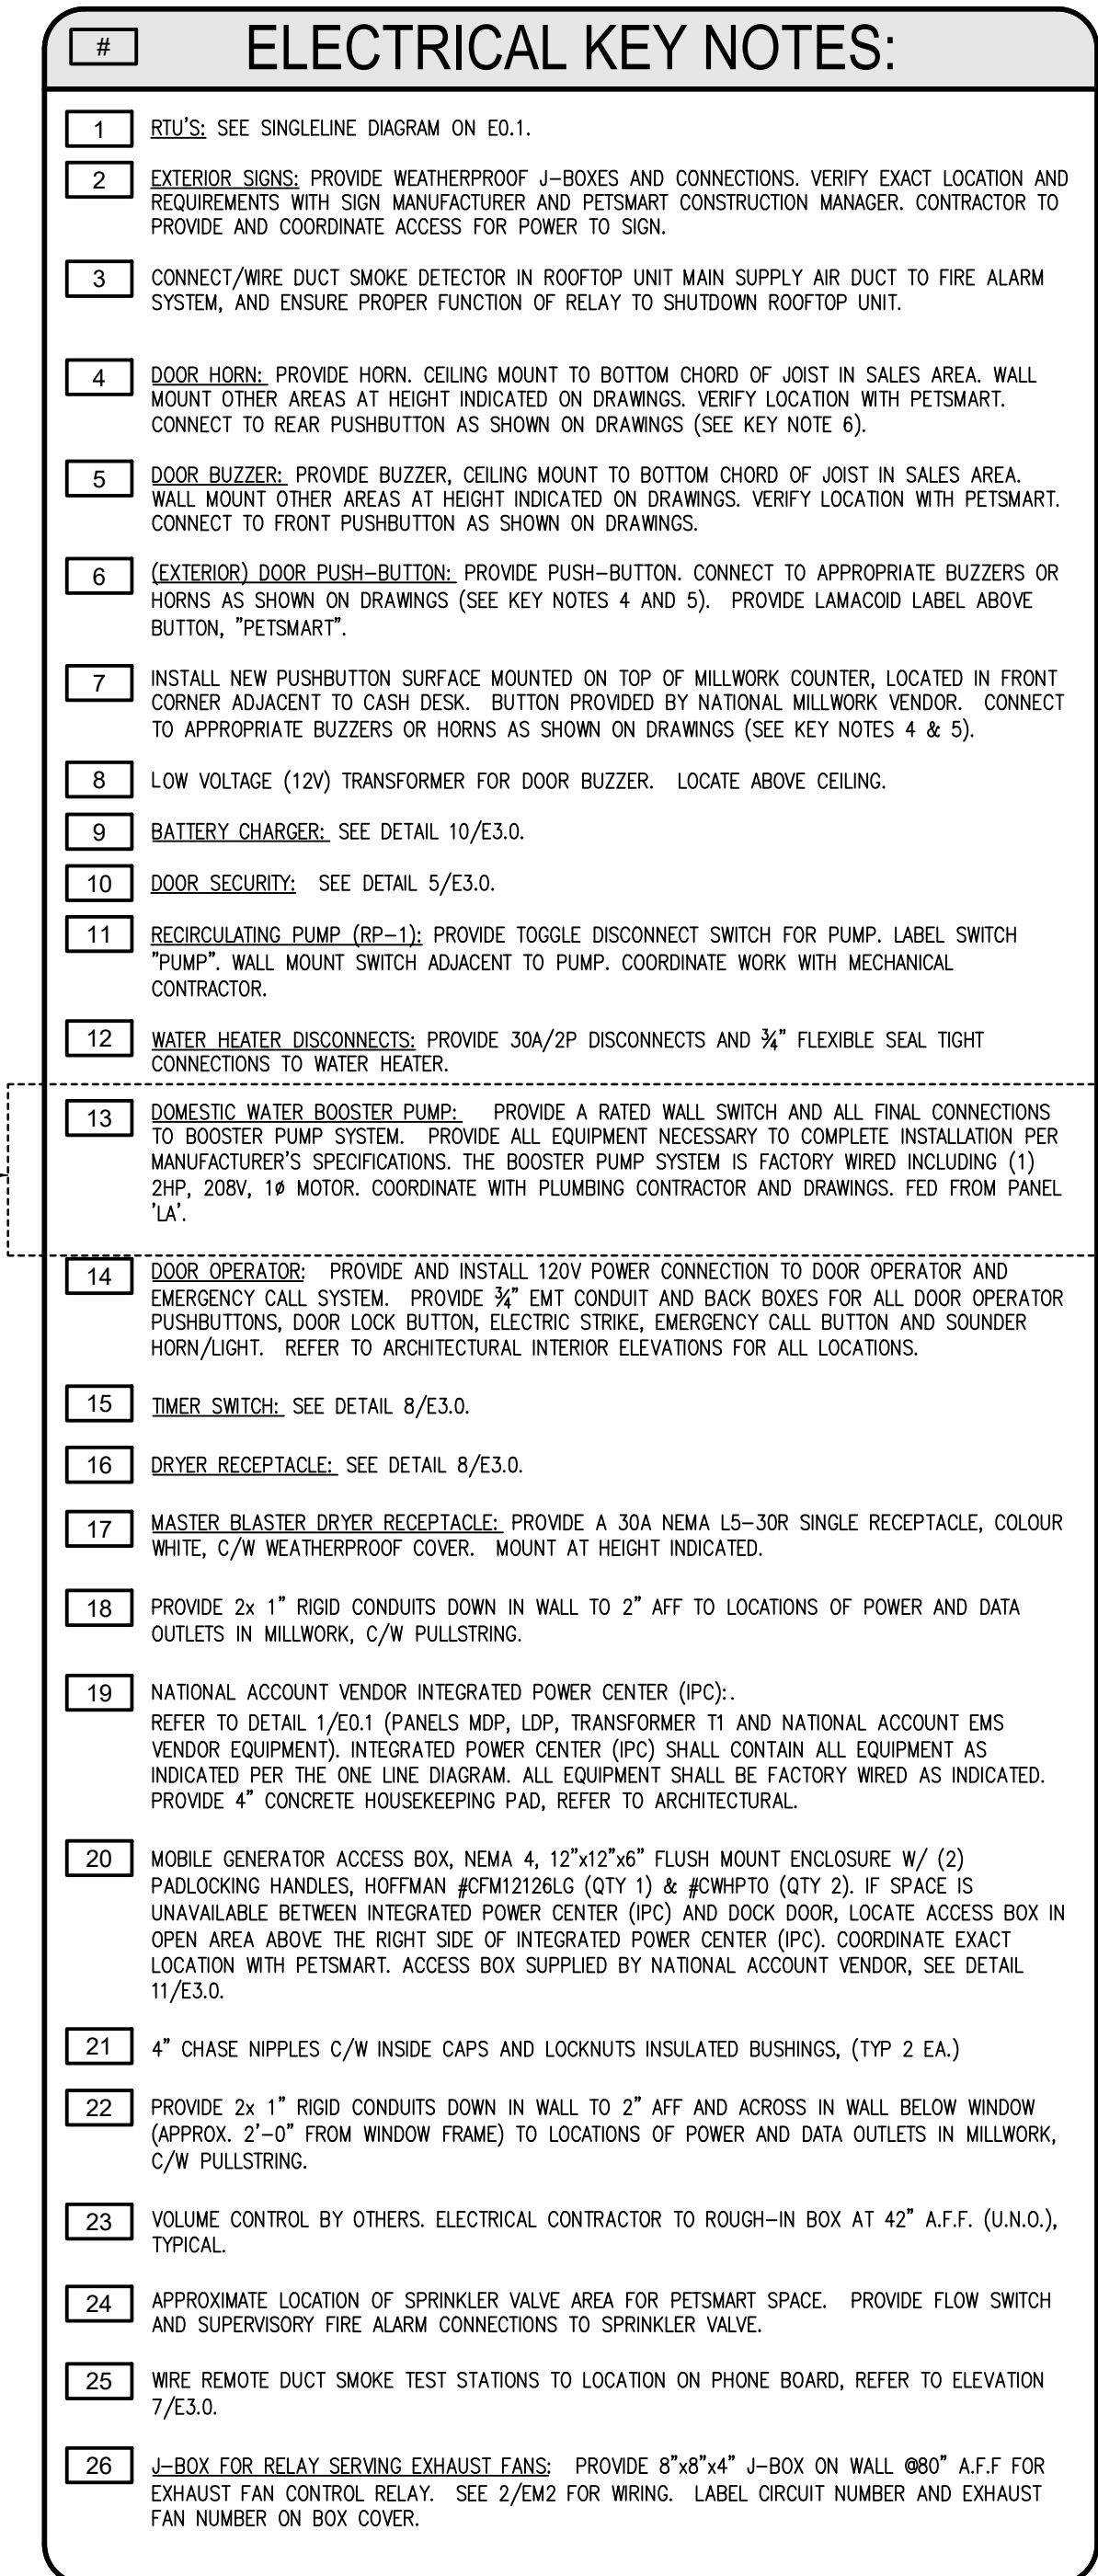


**PET SMART**  
19601 North 27th Avenue  
Phoenix, Arizona 85027 - (623) 580-6100

14K 2025  
CANADIAN  
INSTRUCTION  
SET

**FEBRUARY 12, 2025**

CONSULTA

ARCHITECT

SEAL:

CITY SEAL:

DISCLAIMER: COPYRIGHTED AND DESIGN IS COPYRIGHT PROTECTED WHICH SHALL NOT BE USED, REPRODUCED OR REVISED WITHOUT WRITTEN PERMISSION BY PETSMAST. THE CONTRACTOR SHALL CHECK AND VERIFY ALL DIMENSIONS AND UTILITY LOCATIONS AND REPORT ALL ERRORS AND OMISSIONS PRIOR TO COMMENCING WORK.

THIS DRAWING IS NOT TO BE SCALED.

[illegible]

|                 |     |                                                                                             |  |
|-----------------|-----|---------------------------------------------------------------------------------------------|--|
| PROJECT NO:     |     | DATE:                                                                                       |  |
| CA0045686.0146  |     | 02.12.25                                                                                    |  |
| ORIGINAL SCALE: |     | IF THIS BAR IS NOT 1"<br>LONG, ADJUST YOUR<br>PLOTTING SCALE.                               |  |
| AS NOTED        |     |                                                                                             |  |
| DESIGNED BY:    |     |                                                                                             |  |
| DRAWN BY:       |     |                                                                                             |  |
| CHECKED BY:     |     |                                                                                             |  |
| PAGE #:         |     | <br>1" |  |
| 49              | OF: | 53                                                                                          |  |

ELECTRICAL

ENLARGED  
POWER FLOOR PLAN

SHEET NUMBER: **E2.1**