
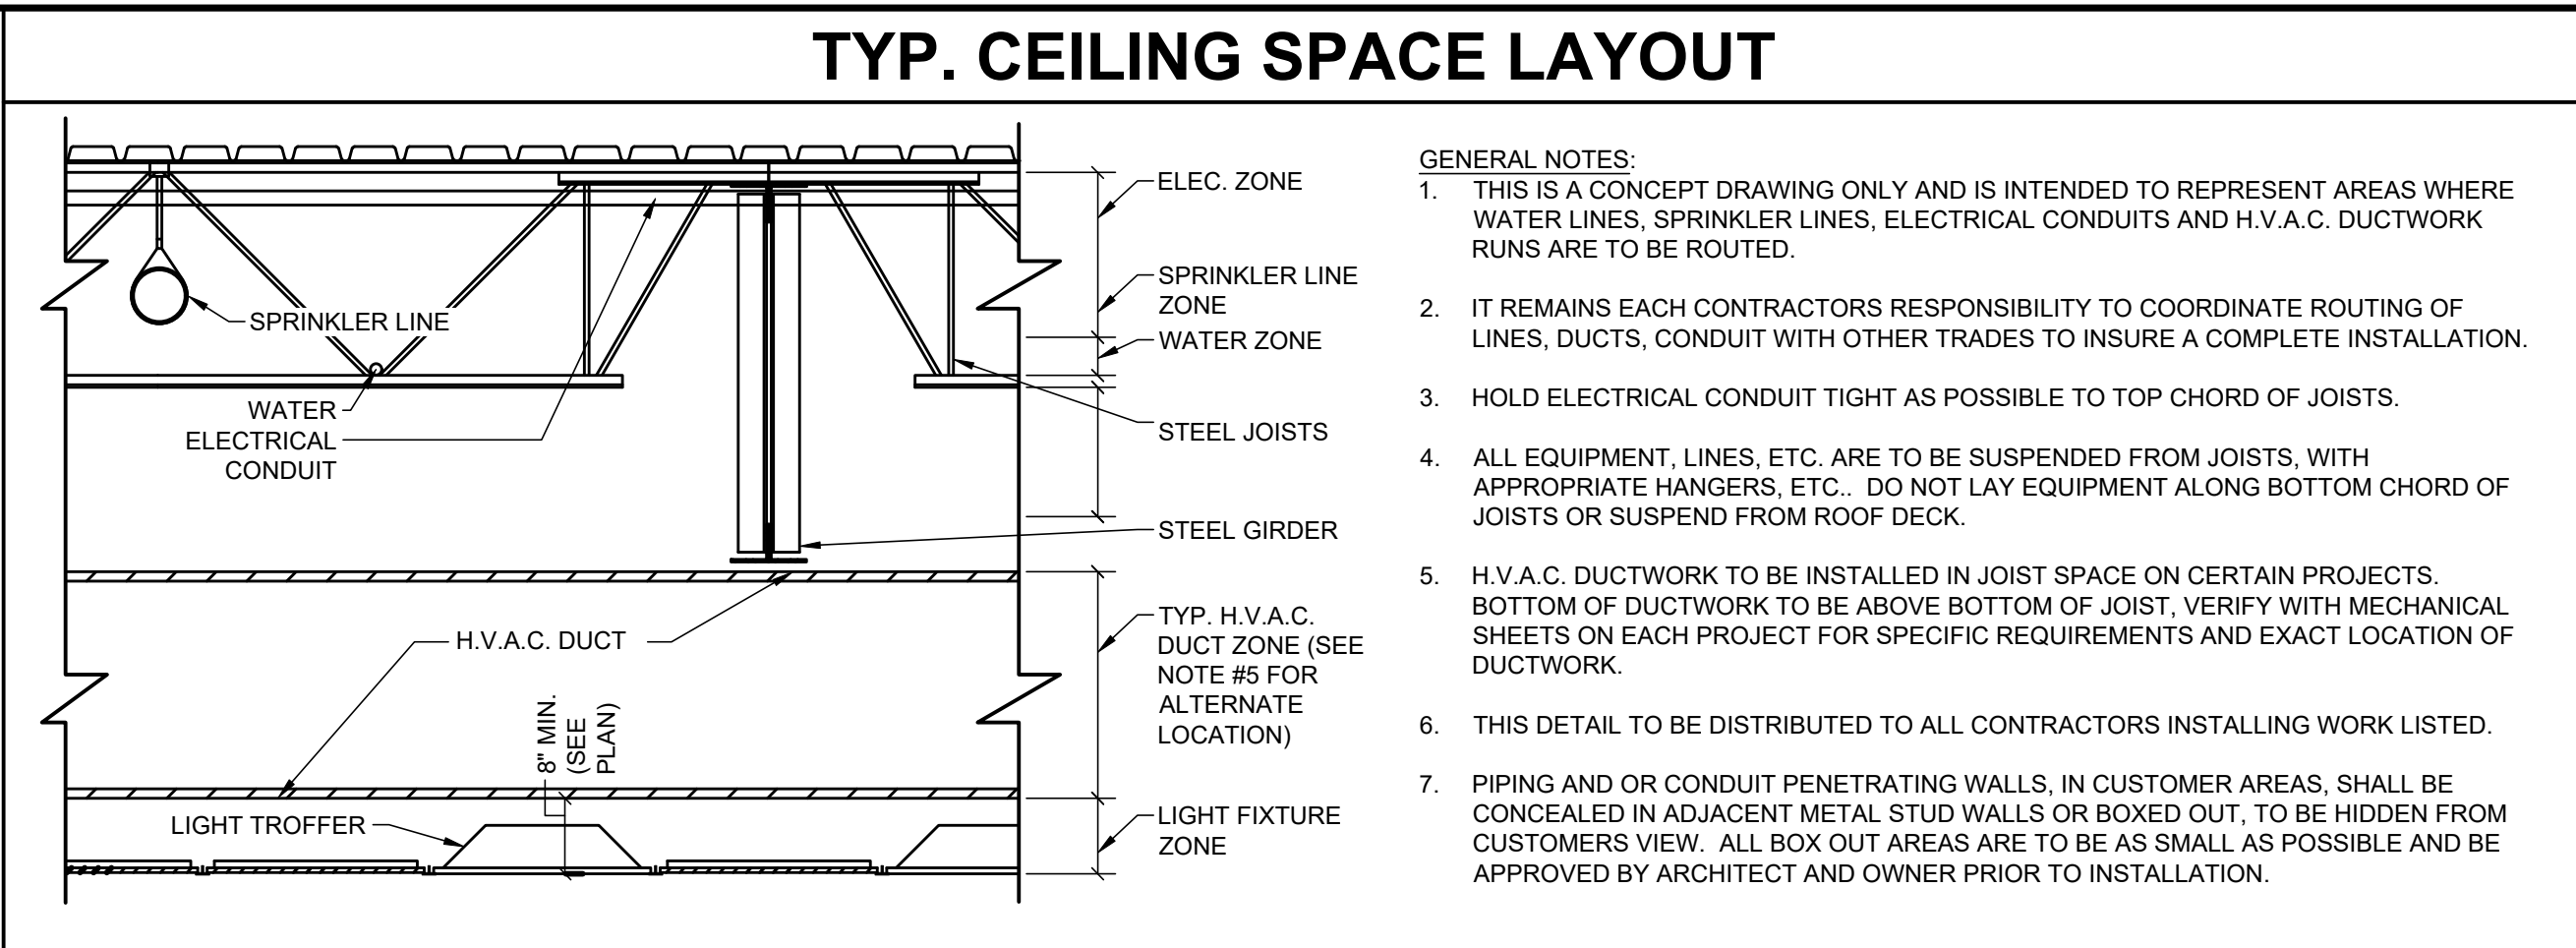


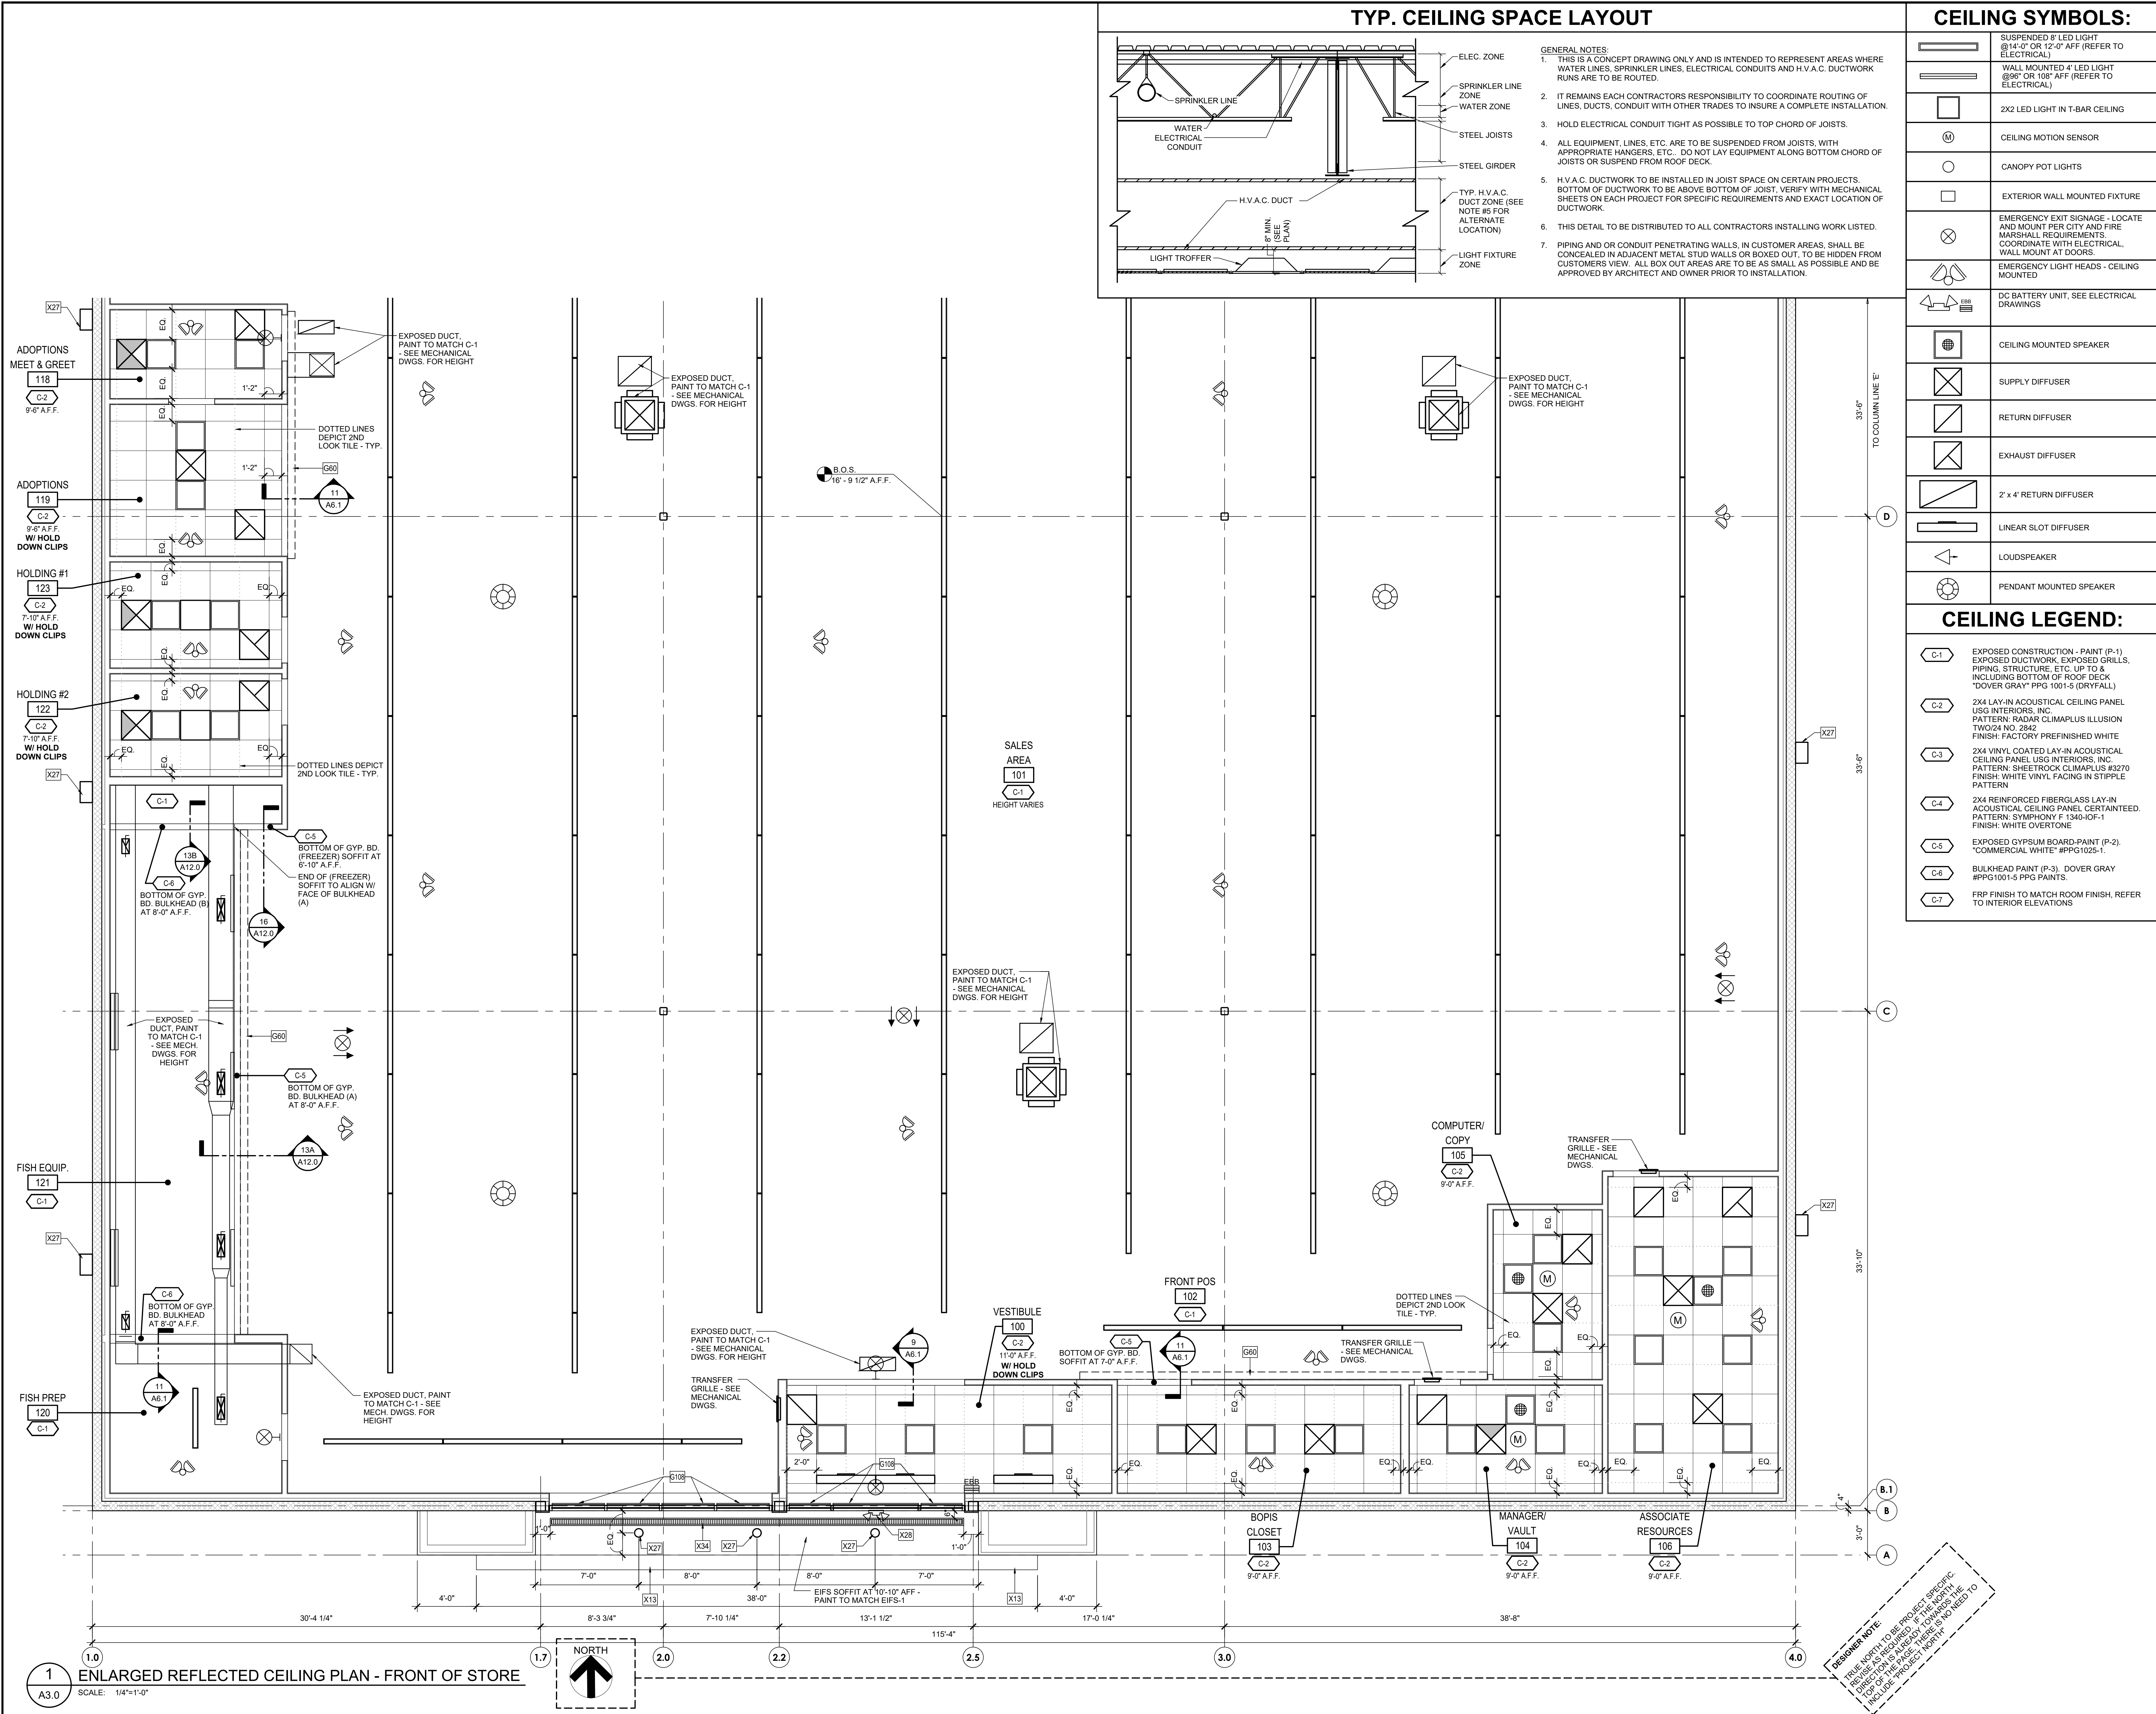

CEILING SYMBOLS:	
	SUSPENDED 8' LED LIGHT @ 14'-0" OR 12'-0" AFF (REFER TO ELECTRICAL)
	WALL MOUNTED 4' LED LIGHT @ 96" OR 108" AFF (REFER TO ELECTRICAL)
	2X2 LED LIGHT IN T-BAR CEILING
	CEILING MOTION SENSOR
	CANOPY POT LIGHTS
	EXTERIOR WALL MOUNTED FIXTURE
	EMERGENCY EXIT SIGNAGE - LOCATE AND MOUNT PER CITY AND FIRE MARSHALL REQUIREMENTS. COORDINATE WITH ELECTRICAL, WALL MOUNT AT DOORS.
	EMERGENCY LIGHT HEADS - CEILING MOUNTED
	DC BATTERY UNIT, SEE ELECTRICAL DRAWINGS
	CEILING MOUNTED SPEAKER
	SUPPLY DIFFUSER
	RETURN DIFFUSER
	EXHAUST DIFFUSER
	2' x 4' RETURN DIFFUSER
	LINEAR SLOT DIFFUSER
	LOUDSPEAKER
	PENDANT MOUNTED SPEAKER
CEILING LEGEND:	
	EXPOSED CONSTRUCTION - PAINT (P-1) EXPOSED DUCTWORK, EXPOSED GRILLS, PIPING, STRUCTURE, ETC. UP TO & INCLUDING BOTTOM OF ROOF DECK "DOVER GRAY" PPG 1001-5 (DRYFALL)
	2X4 LAY-IN ACOUSTICAL CEILING PANEL USG INTERIORS, INC. PATTERN: RADAR CLIMAPLUS ILLUSION TWO/24 NO. 2842 FINISH: FACTORY PREFINISHED WHITE
	2X4 VINYL COATED LAY-IN ACOUSTICAL CEILING PANEL USG INTERIORS, INC. PATTERN: SHEETROCK CLIMAPLUS #3270 FINISH: WHITE VINYL FACING IN STIPPLE PATTERN
	2X4 REINFORCED FIBERGLASS LAY-IN ACOUSTICAL CEILING PANEL CERTANTEED. PATTERN: SYMPHONY F 1340-IOF-1 FINISH: WHITE OVERTONE
	EXPOSED GYPSUM BOARD-PAINT (P-2), "COMMERCIAL WHITE" #PPG1025-1
	BULKHEAD PAINT (P-3), DOVER GRAY #PPG1001-5 PPG PAINTS.
	FRP FINISH TO MATCH ROOM FINISH, REFER TO INTERIOR ELEVATIONS

TENANT:

19601 North 27th Avenue

Phoenix, Arizona 85027 - (623) 580-6100

PROJECT:

16K 2025 US INSTRUCTION SET

ARCHITECT:

CONSULTANT:

DATE:

FEBRUARY 12, 2025

DISCLAIMER:

THIS DRAWING AND DESIGN IN COPYRIGHT PROTECTED WHICH SHALL NOT BE USED, REPRODUCED OR REVISED WITHOUT WRITTEN PERMISSION BY PETSMART. THE CONTRACTOR SHALL CHECK AND VERIFY ALL DIMENSIONS AND UTILITY LOCATIONS AND REPORT ALL ERRORS AND OMISSIONS PRIOR TO COMMENCING WORK. THIS DRAWING IS NOT TO BE SCALED.

ISSUED FOR:

PROJECT NO:

16K 2025 US INSTRUCTION SET

ORIGINAL SCALE:

AS INDICATED

DRAWN BY:

XXX

CHECKED BY:

XXX

PAGE #:

10 OF 47

DISCIPLINE:

ARCHITECTURAL

TITLE:

ENLARGED REFLECTED CEILING PLAN

SHEET NUMBER:

A3.0

IF THIS BAR IS NOT 1" LONG, ADJUST YOUR PLOTTING SCALE

1"