
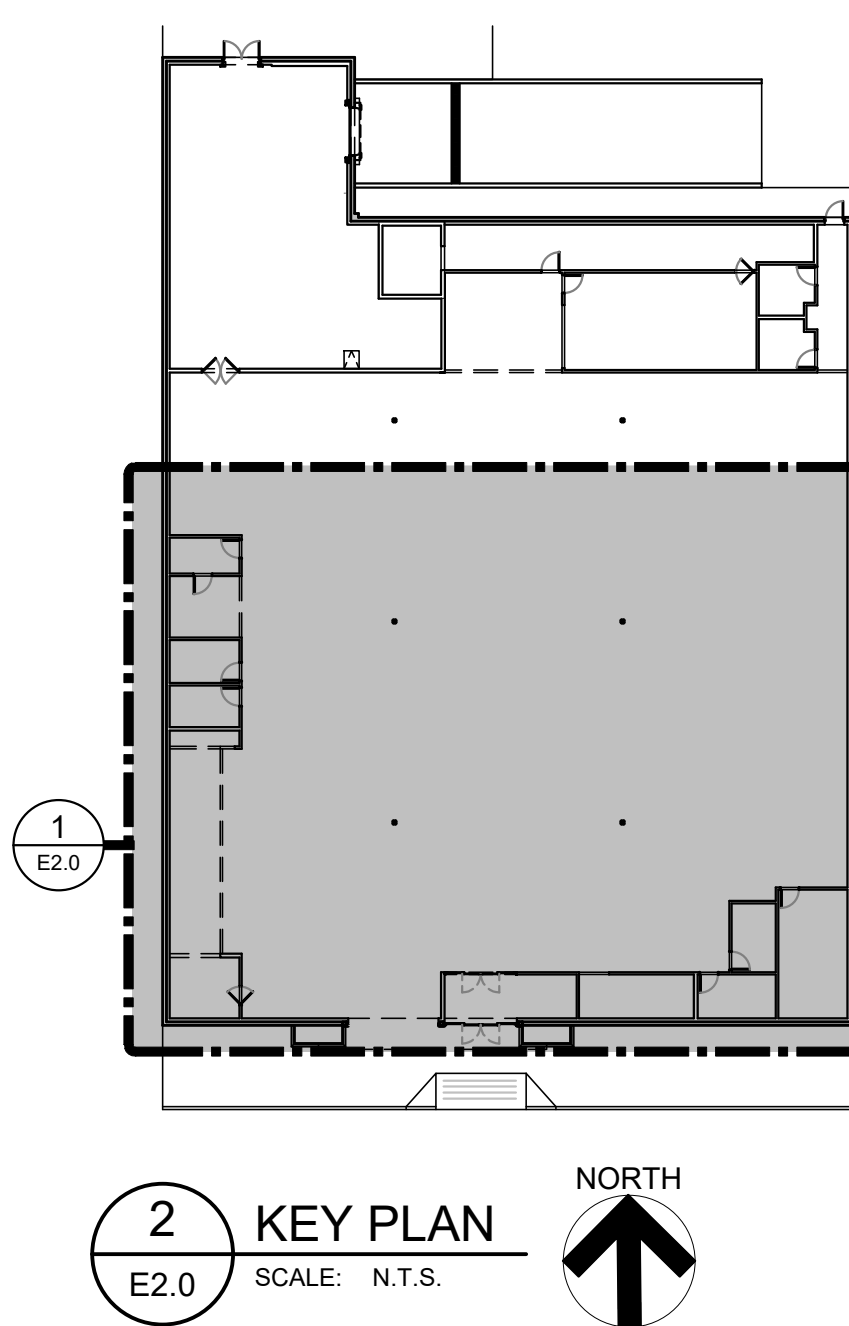


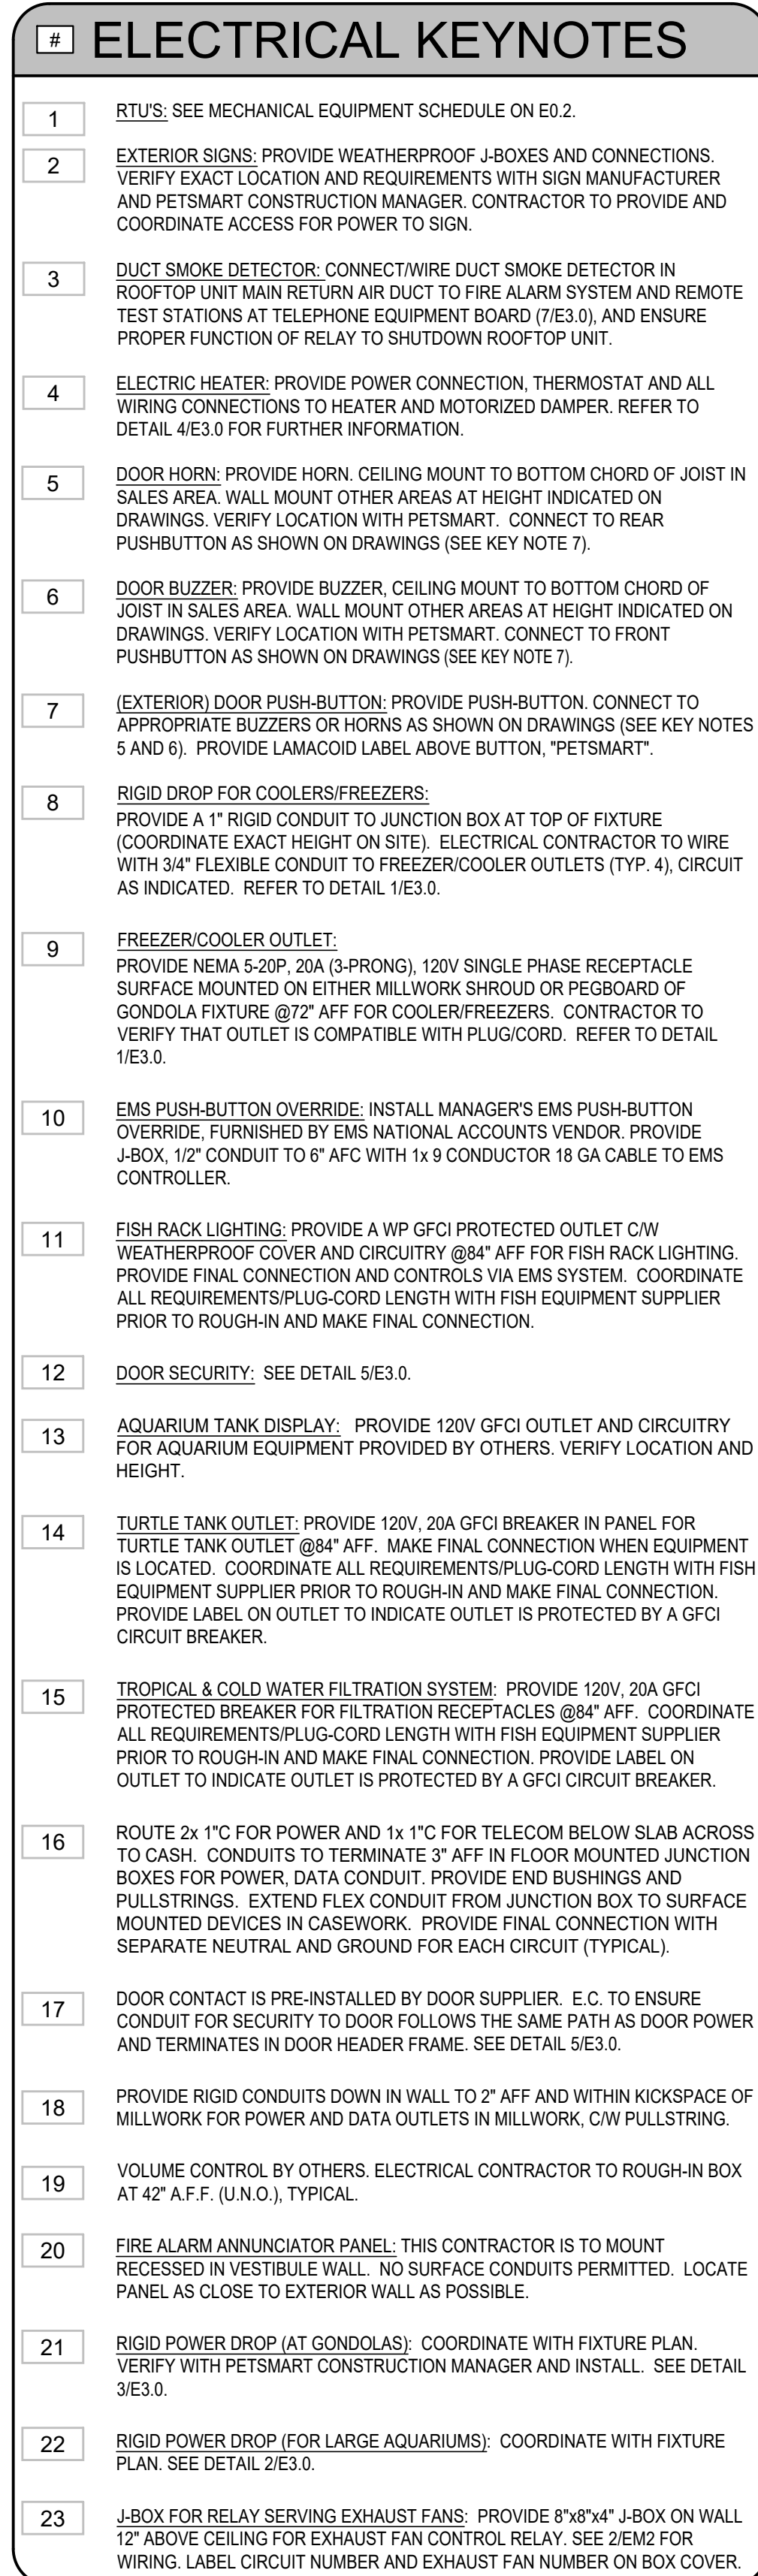

TENANT: PETSMART 19601 North 27th Avenue Phoenix, Arizona 85027 - (623) 580-6100		
PROJECT: 16K 2025 US INSTRUCTION SET FEBRUARY 12, 2025		
ARCHITECT:		
CONSULTANT:		
SEAL:		
CITY SEAL:		
DISCLAIMER: THIS DRAWING AND DESIGN IS COPYRIGHT PROTECTED WHICH SHALL NOT BE USED, REPRODUCED OR REVISED WITHOUT WRITTEN PERMISSION BY PETSMART. THE CONTRACTOR SHALL CHECK AND VERIFY ALL DIMENSIONS AND UTILITY LOCATIONS AND REPORT ALL ERRORS AND OMISSIONS PRIOR TO COMMENCING WORK. <u>THIS DRAWING IS NOT TO BE SCALED.</u>		
ISSUED FOR:		
#	DESCRIPTION	DATE
PROJECT NO. 16K 2025 US INSTRUCTION SET		
ORIGINAL SCALE: AS INDICATED		IF THIS BAR IS NOT 1" LONG ADJUST YOUR PLOTTING SCALE
DRAWN BY: XXX	XXX	
CHECKED BY: XXX	XXX	
PAGE #. 42	OF: 47	
DISCIPLINE: ELECTRICAL		1"
TITLE: ENLARGED POWER PLAN		
SHEET NUMBER: E2.0		