


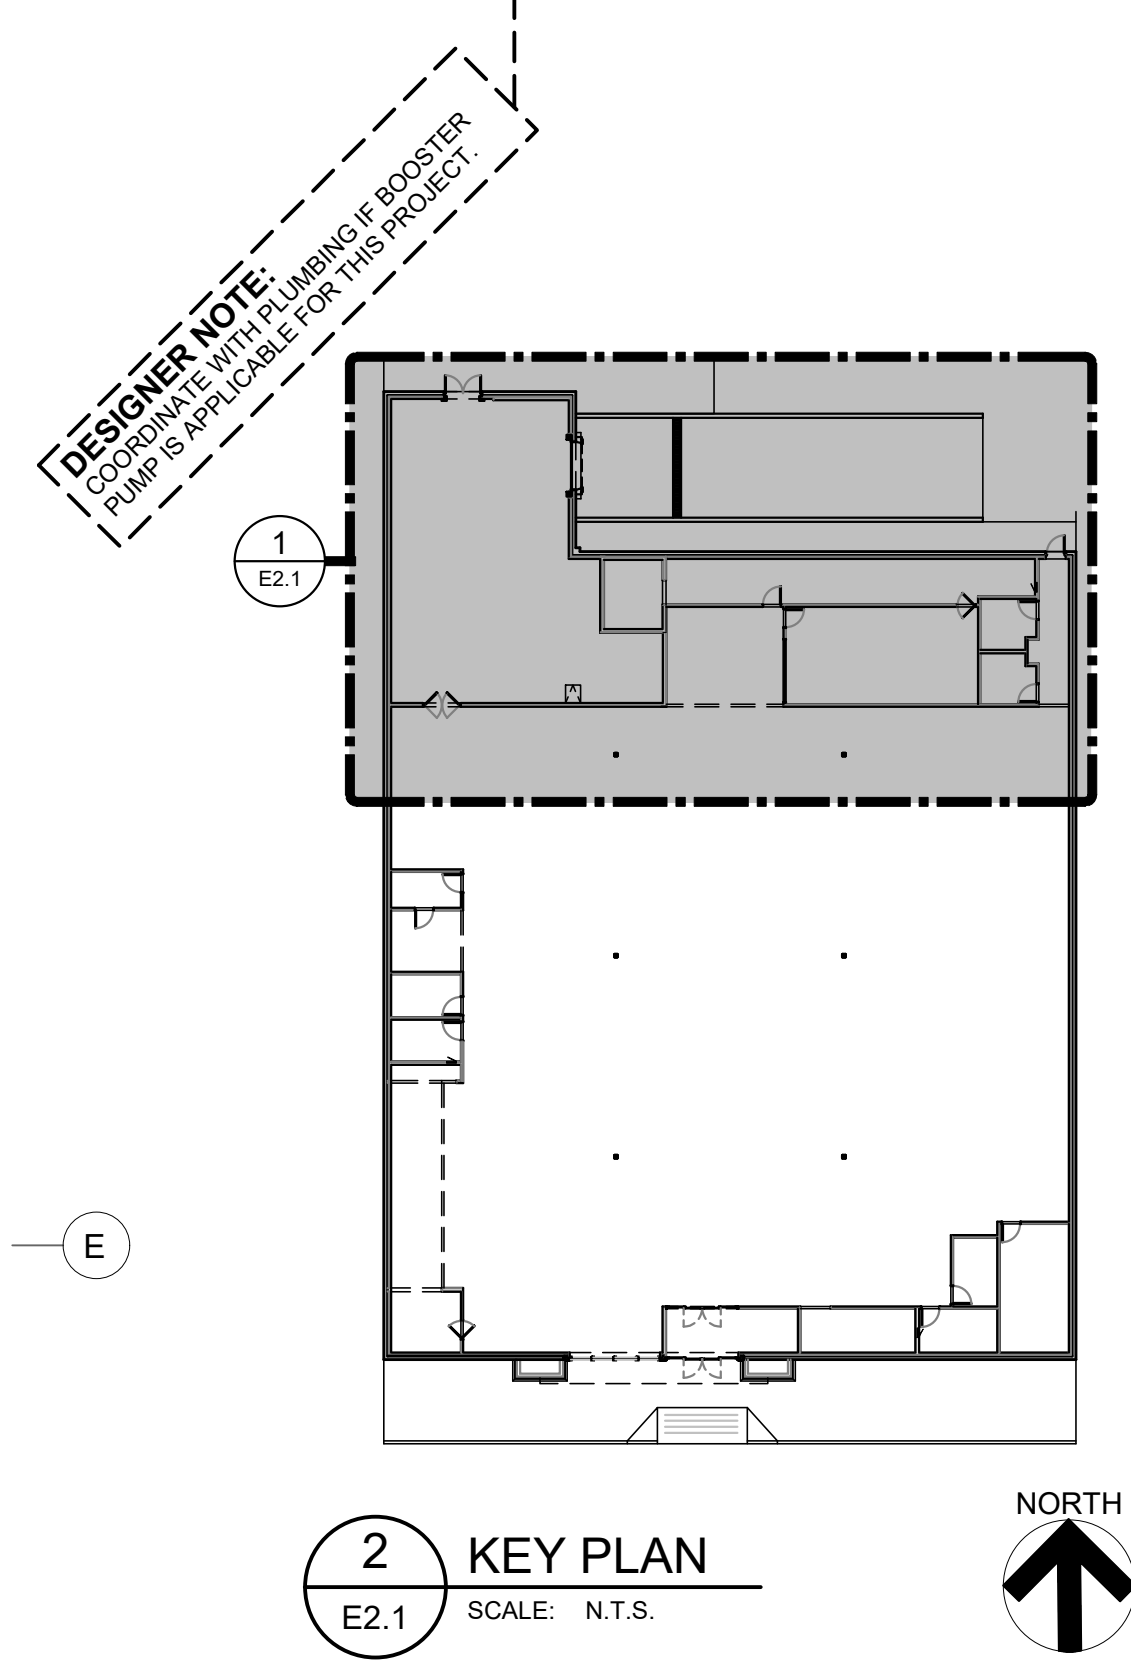

PROJECT:		
SUBJECT:		
DRAWING TITLE: PETSMART 19601 North 27th Avenue Phoenix, Arizona 85027 - (623) 580-6100		
PROJECT NO.: 16K 2025 US INSTRUCTION SET		
DATE OF ISSUE: FEBRUARY 12, 2025		
DESIGNED BY:		
CHECKED BY:		
APPROVED BY:		
CONSULTANT:		
SEAL:		
SCALE:		
NOTES:		
DISCLAIMER:		
THE DRAWING AND DESIGN IS COPYRIGHT PROTECTED WHICH SHALL NOT BE USED, REPRODUCED OR REVISED WITHOUT WRITTEN PERMISSION BY PETSMART. THE CONTRACTOR SHALL CHECK AND VERIFY ALL DIMENSIONS AND UTILITY LOCATIONS AND REPORT ALL ERRORS AND OMISSIONS PRIOR TO COMMENCING WORK.		
THIS DRAWING IS NOT TO BE SCALED.		
ISSUED FOR:		
No.	DESCRIPTION	DATE
PROJECT NO.: 16K 2025 US INSTRUCTION SET		
ORIGINAL SCALE: AS INDICATED		
DRAWN BY:	XXX	IF THIS BAR IS NOT 1" LONG, ADJUST YOUR PLOTTING SCALE 1"
CHECKED BY:	XXX	
AGE #:		
43	OF: 47	
DISCIPLINE: ELECTRICAL		
TITLE: ENLARGED POWER PLAN		
SHEET NUMBER: E2.1		