

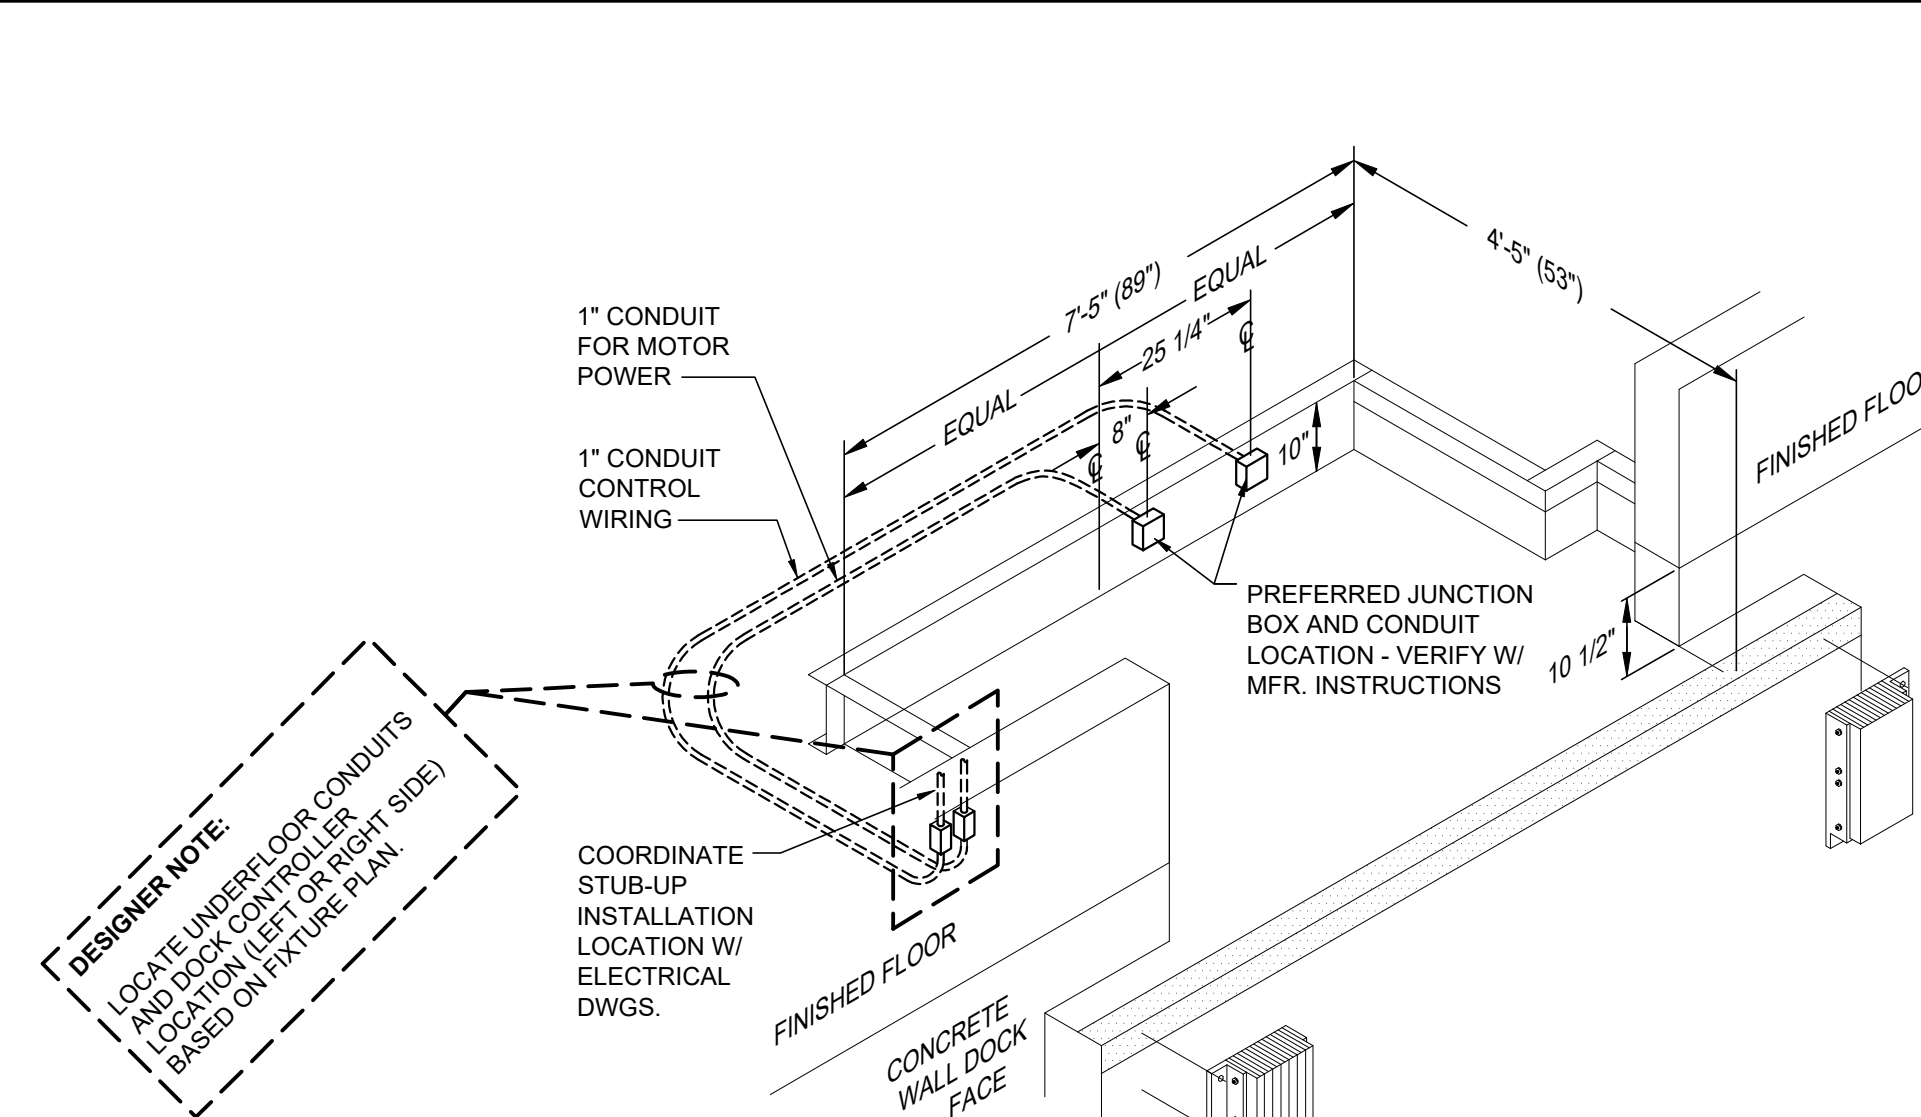


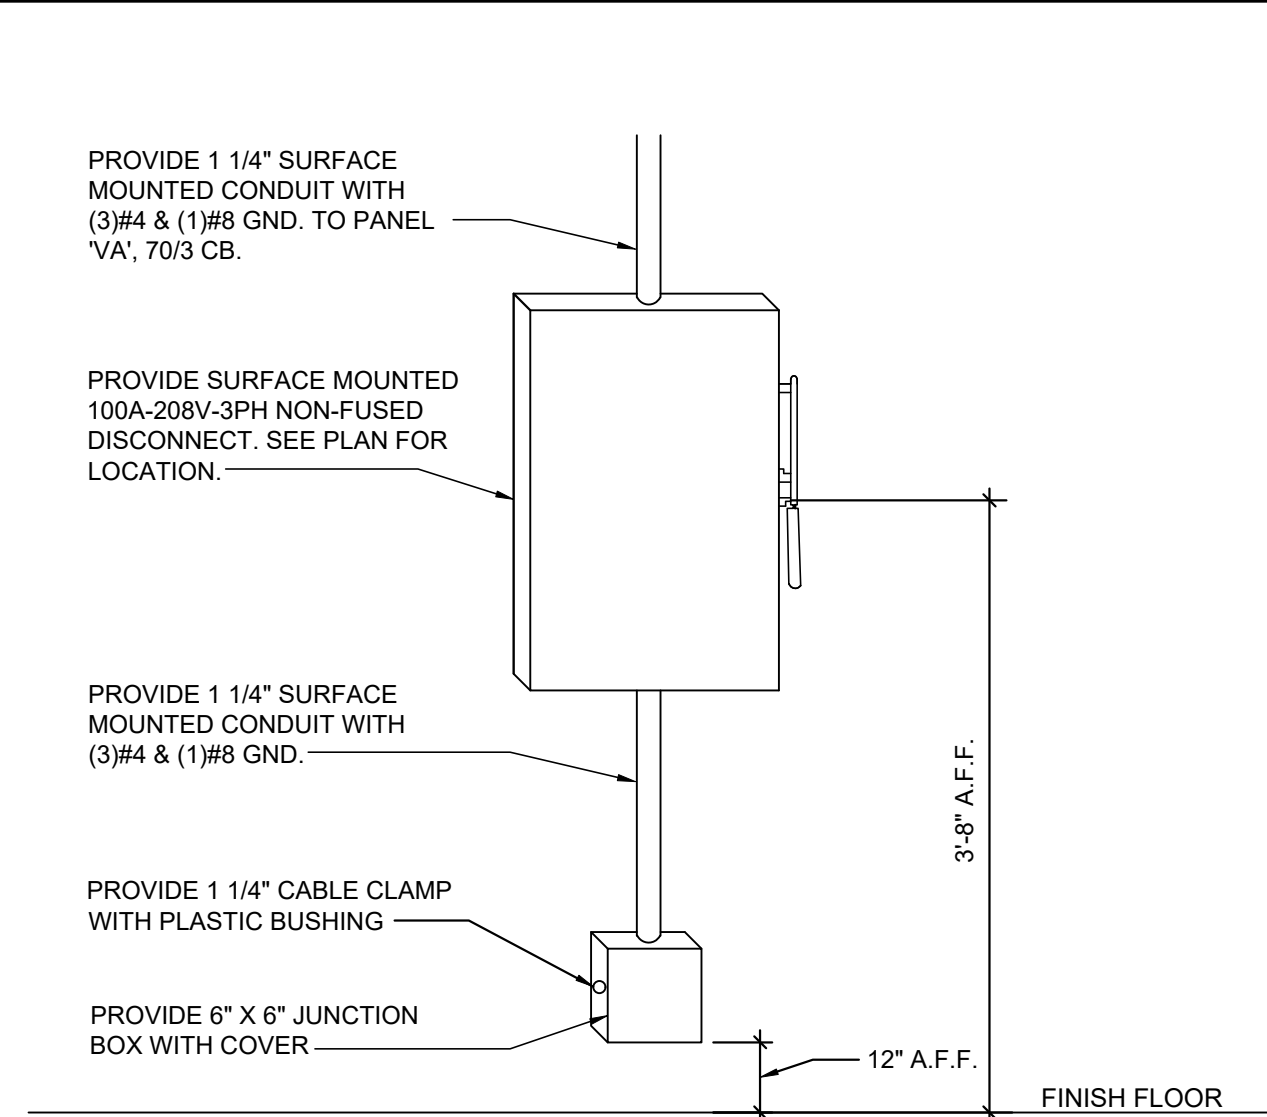

The diagram illustrates three mounting configurations for a hanging receptacle, enclosed in a dashed rectangular border. At the top center, a dimension line indicates a height of 12 inches from the ceiling to the top of the mounting box.

- SIDE A:** Shows a side view of a GFI duplex receptacle mounted on a wall. Below it, the text reads: "SIDE A", "GFI DUPLEX", and "RECEPTACLE".
- FRONT:** Shows a front view of a Hubbell portable outlet box. Below it, the text reads: "FRONT", "HUBBELL", "PORTABLE", and "OUTLET BOX".
- SIDE B:** Shows a side view of a duplex receptacle with a wire passing through a GFI receptacle on the opposite side (Side A). Below it, the text reads: "SIDE B", "DUPLEX", "RECEPTACLE", "(WIRE THROUGH", "GFI RECEPTACLE", and "ON SIDE A)".


8 BATTERY CHARGER ELEVATION
E3.0 SCALE: N.T.S.

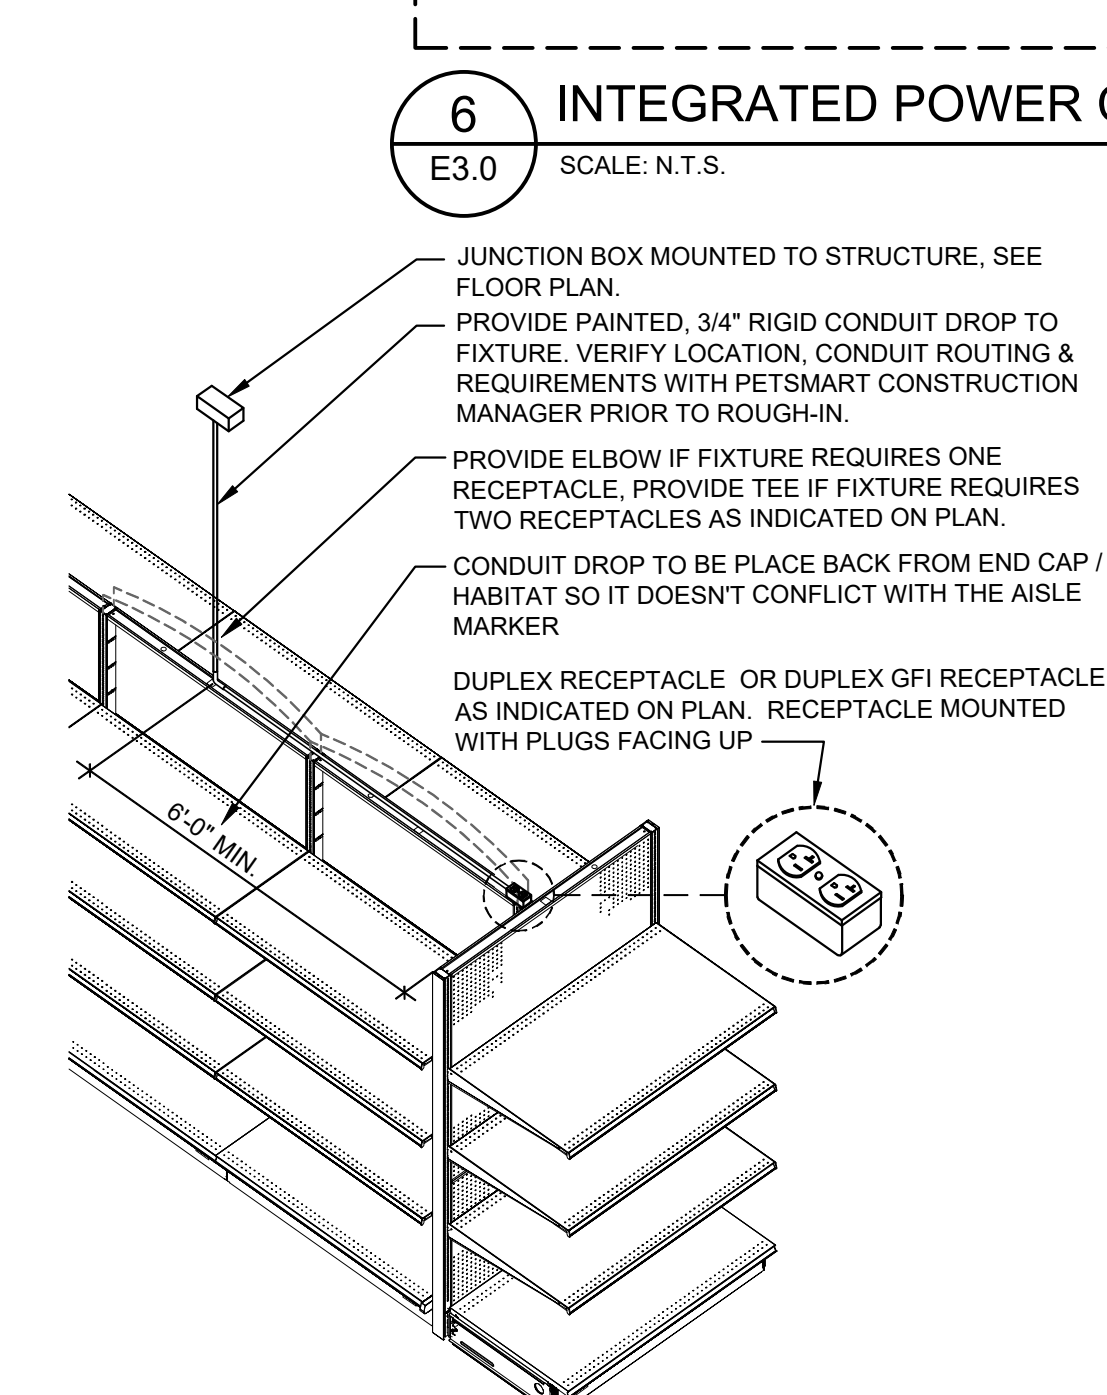

2 RIGID POWER DROP AT LARGE AQUARIUMS
E3.0 SCALE: N.T.S.

1 RIGID POWER DROP AT FREEZERS/COOLERS

1 RIGID POWER DROP AT FREEZERS/COOLERS

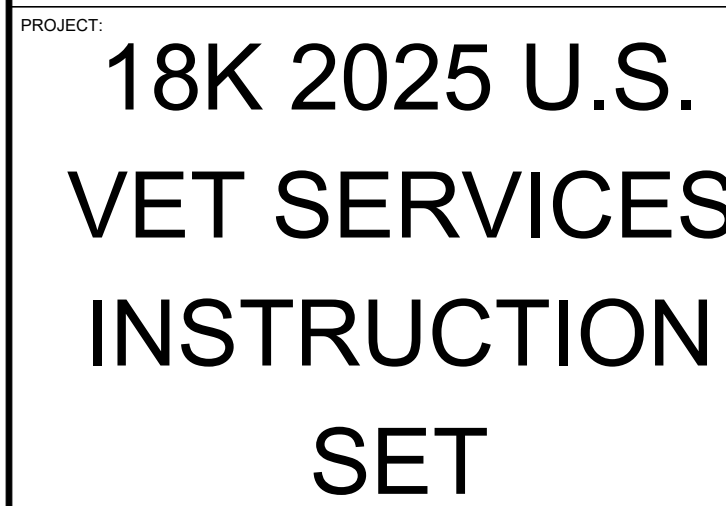

FEBRUARY 12, 2025

ARCHITECT

CONSULTA

8FAM®

CITY SEAL:

DISCLAIMER:

THIS DRAWING AND DESIGN IN COPYRIGHT PROTECTED WHICH SHALL NOT BE USED, REPRODUCED OR REVISED WITHOUT WRITTEN PERMISSION BY PETSMART. THE CONTRACTOR SHALL CHECK AND VERIFY ALL DIMENSIONS AND UTILITY LOCATIONS AND REPORT ALL ERRORS AND OMISSIONS PRIOR TO COMMENCING WORK.

THIS DRAWING IS NOT TO BE SCALED.

ISSUED FOR

[illegible]

PROJECT N

PROJECT NO. 18K 2025 US INSTRUCTION SET

ORIGINAL SCALE:
AS INDICATED

DRAWN BY:

CHECKED BY _____

PAGE #

--	--

100

ELECTRICAL POWER DETAILS

SHEET NUM

E3.0