
 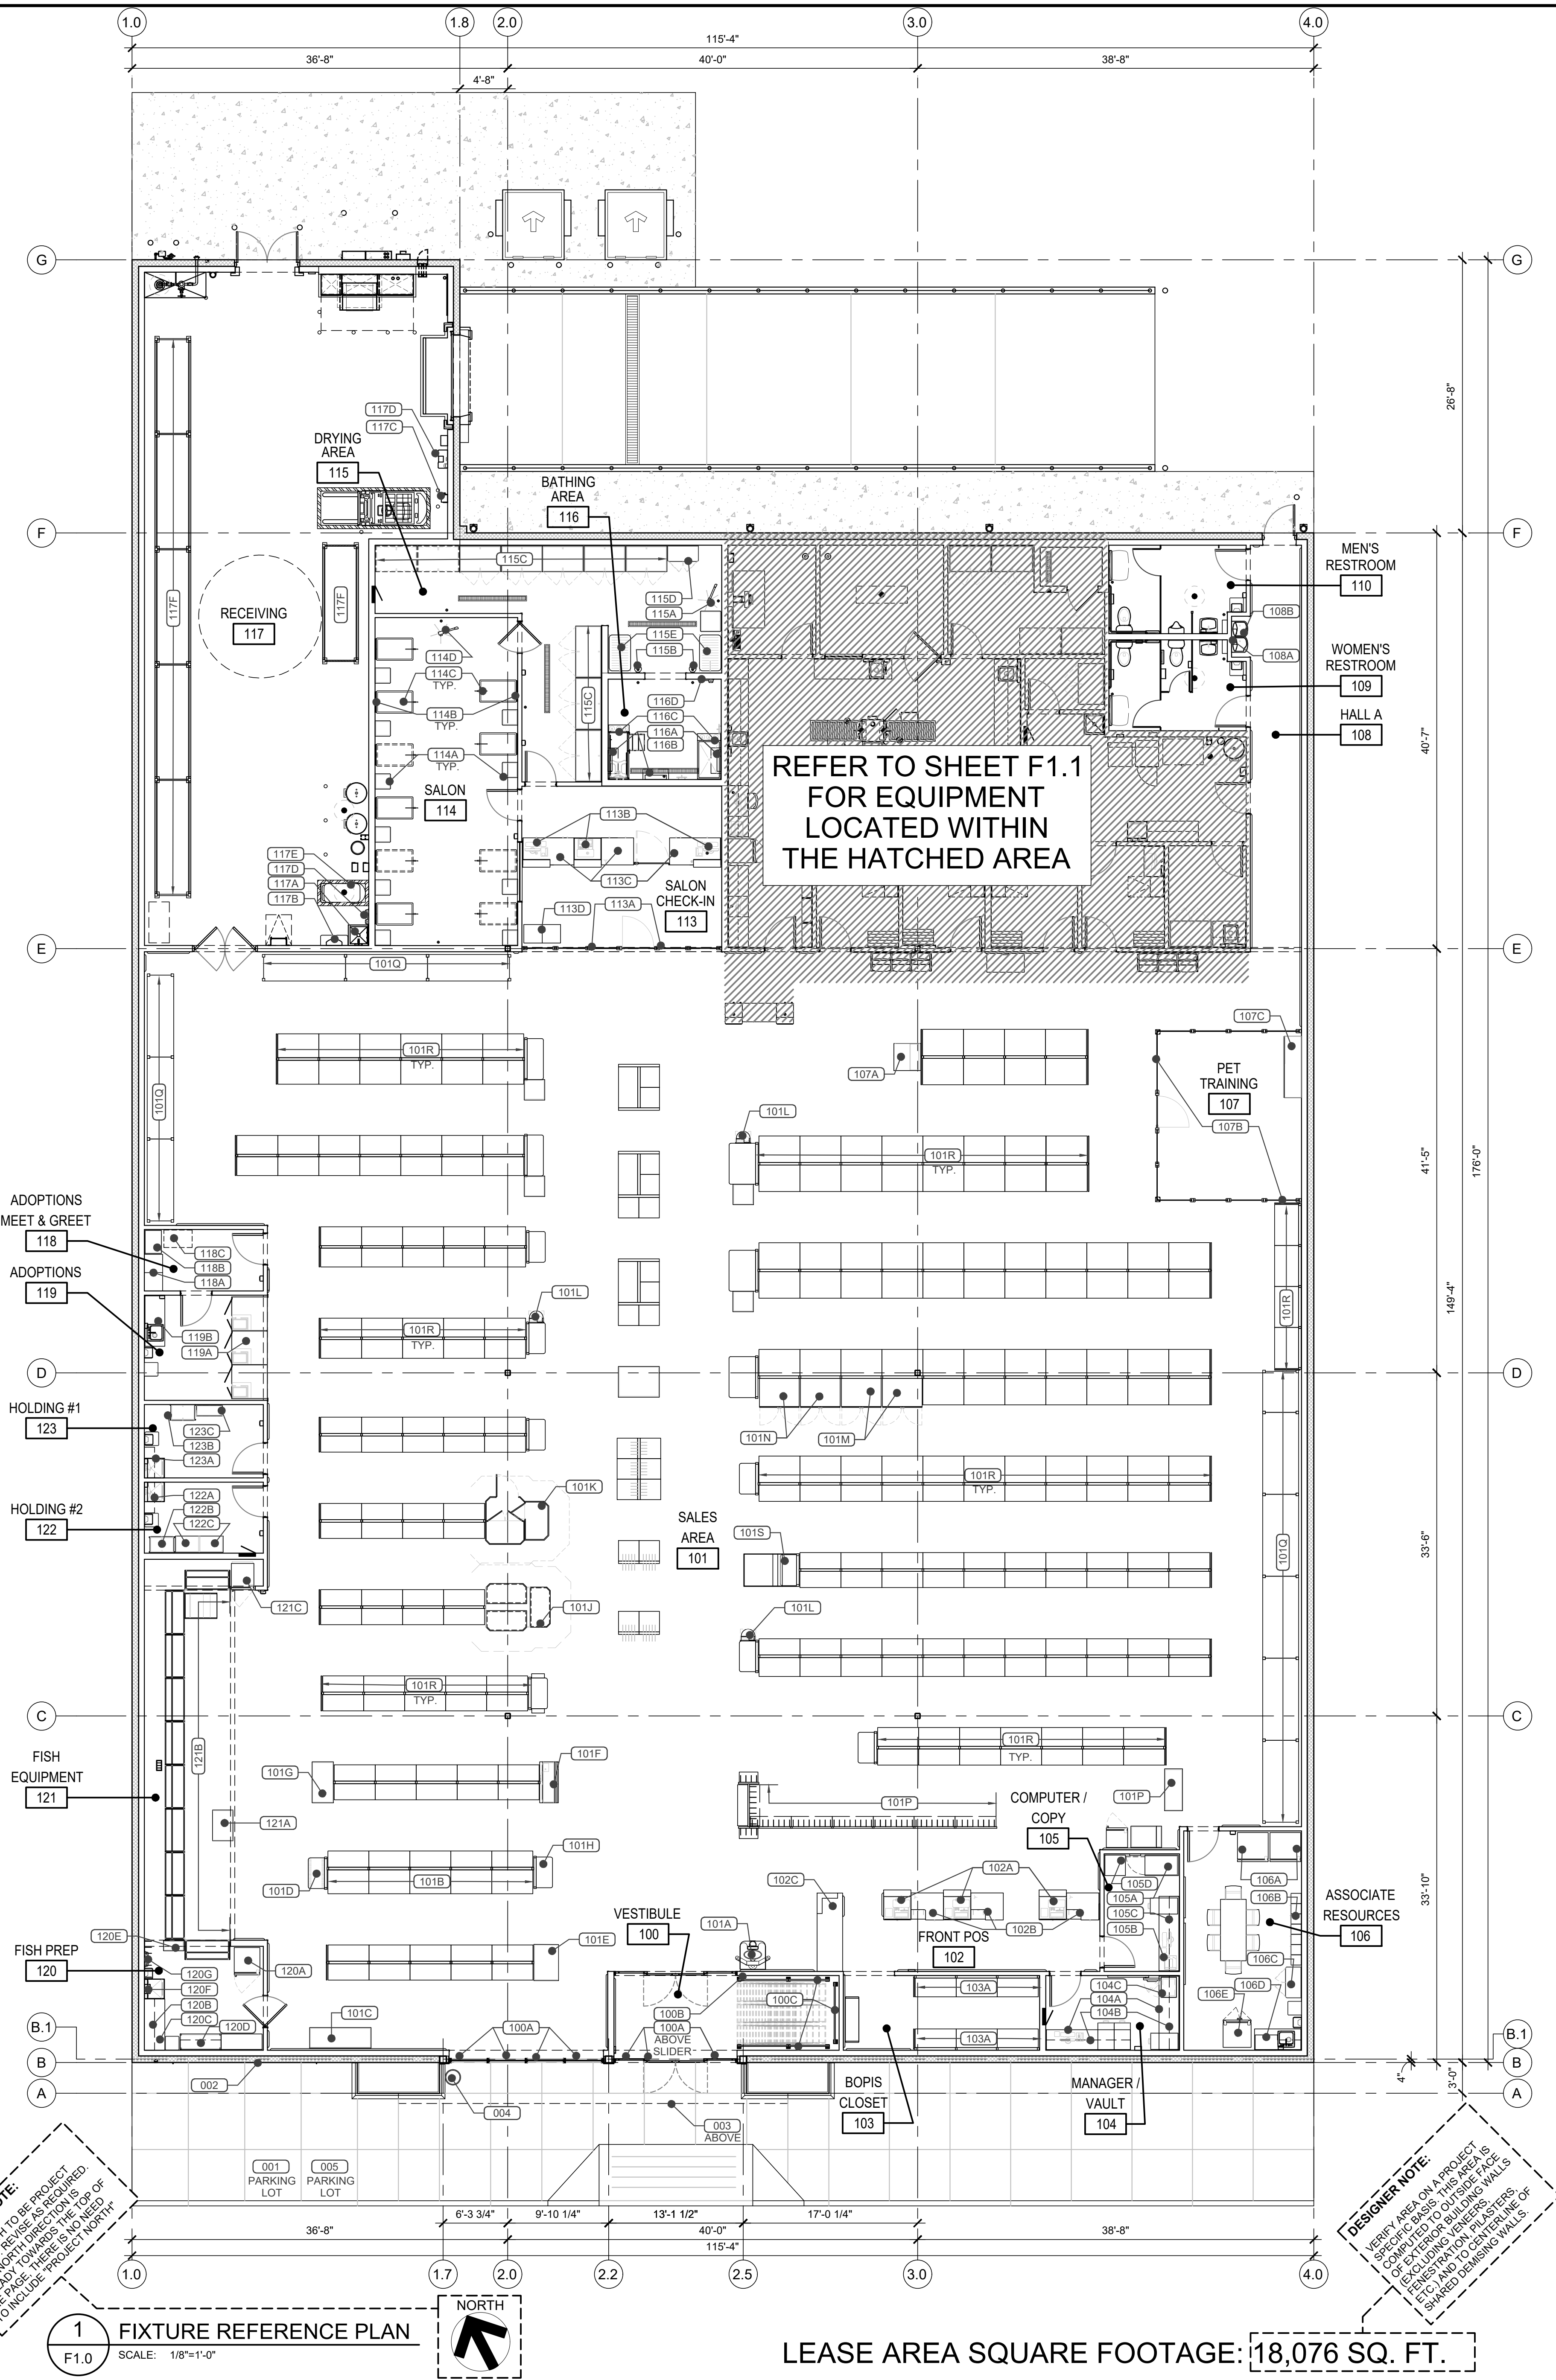


EQUIPMENT COORDINATION SCHEDULE									
GENERAL NOTES:		1. ALL ITEMS NOTED AS ***** ARE SUPPLIED AND INSTALLED IN THE MILLWORK PACKAGE BY THE NATIONAL ACCOUNT MILLWORK VENDOR AS PART OF THE G.C. SCOPE AND PRICE. 2. MILLWORK ITEMS NOTED AS (PAID FOR BY PETSMART) ARE NOT A PART OF THE G.C. PRICE BUT ARE STILL DELIVERED AND INSTALLED AS PART OF THE G.C. MILLWORK PACKAGE . 3. ALL MILLWORK IS TO RECEIVE RUBBER COVE BASE WHICH IS SUPPLIED AND INSTALLED BY THE G.C. 4. ALL BLOCKING AND BACKING IS SUPPLIED AND INSTALLED BY THE G.C.							
ROOM NAME & NUMBER	FIXTURE REFERENCE NUMBER	ITEM	SUPPLIED AND INSTALLED BY OTHERS	SUPPLIED BY OTHERS INSTALLED BY G.C.	SUPPLIED AND INSTALLED BY G.C.	ELECTRICAL REQUIRED BY G.C.	PLUMBING REQUIRED BY G.C.	PLUMBING FINAL CONNECTION BY G.C.	REMARKS
BUILDING EXTERIOR	001	PET CLEANUP STATION (EXTERIOR)		●					ALLOW FOR 4 BOLT MOUNTS TO HARD LANDSCAPE.
	002	COMING SOON BANNER			●				SEE A0.1 FOR ORDER FORM.
	003	BIRD DETERRENT			●	●			SUPPLIED BY NATIONAL ACCOUNT LIGHTING VENDOR AS PART OF G.C. SCOPE.
	004	ASH/TRASH CAN			●				SEE F2.0 FOR SPEC AND REQUIRED VENDOR. (MATCH CENTER SPEC WHEN REQUIRED)
	005	CART CORRAL			●				INSTALL CART CORRAL(S) AT FRONT PARKING FIELD FOR PUNCH INSPECTION DATE. SEE SITE PLAN ON A0.0 FOR LOCATION. SEE F2.0 FOR SPEC AND REQUIRED VENDOR.
VESTIBULE 100	100A	WINDOW BLINDS			●				SEE F2.0 FOR SPEC AND REQUIRED VENDOR.
	100B	FIRE SAFETY PLAN (NOT USED)							NOT USED
	100C	CART BUMPER			●				SEE F2.0 FOR SPEC AND REQUIRED VENDOR.
SALES AREA 101	101A	TAG MACHINE	●			●			
	101B	LARGE AQUARIUMS DISPLAY	●			●			
	101C	6' TANK DISPLAY	●			●			
	101D	PLANT DISPLAY FIXTURE	●			●			
	101E	BETTA FIXTURE	●			●			
	101F	REPTILE HABITAT	●			●			
	101G	REPTILE FEEDER FIXTURE	●			●			
	101H	SHO3 FIXTURE	●			●			
	101J	SMALL ANIMAL HABITAT	●			●			
	101K	BIRD HABITAT	●			●			
	101L	PET CLEANUP STATION (INTERIOR)	●						
	101M	COOLER (NATURALS)	●			●			
	101N	FREEZER (NATURALS)	●			●			
	101P	QUEUE LINE SHELVING	●						
	101Q	MINI STEEL RACKING	●						
101R	SHELVING	●			●			SEE ELECTRICAL DRAWINGS FOR POWER DROPS AND DETAILS.	
101S	N&J FIXTURE	●							
FRONT POS 102	102A	TERMINAL CABINET			●	●			***** SEE GENERAL NOTES ABOVE
	102B	SERVICES CABINET			●	●			***** SEE GENERAL NOTES ABOVE
	102C	BOPIS CABINET			●	●			***** SEE GENERAL NOTES ABOVE
BOPIS CLOSET 103	103A	SHELVING	●						
MANAGER/ VAULT 104	104A	COUNTER			●				***** SEE GENERAL NOTES ABOVE
	104B	SHELVING			●				***** SEE GENERAL NOTES ABOVE
	104C	SAFE	●						
COMPUTER COPY 105	105A	IS RACK	●			●			
	105B	COUNTER			●				***** SEE GENERAL NOTES ABOVE
	105C	SHELVING			●				***** SEE GENERAL NOTES ABOVE
	105D	SHRED BIN	●						
ASSOCIATE RESOURCES 106	106A	VENDING MACHINE	●			●			
	106B	LOCKERS	●						
	106C	STORAGE CABINET	●						
	106D	SINK CABINET MILLWORK			●	●	●	●	***** SEE GENERAL NOTES ABOVE
	106E	REFRIGERATOR	●			●	●	●	***** SEE GENERAL NOTES ABOVE (PAID FOR BY PETSMART)
PET TRAINING 107	107A	PET TRAINING PODIUM			●				***** SEE GENERAL NOTES ABOVE (PAID FOR BY PETSMART)
	107B	FENCE AND GATE			●				***** SEE GENERAL NOTES ABOVE
	107C	TRAINING CABINET			●				***** SEE GENERAL NOTES ABOVE (PAID FOR BY PETSMART)
HALL A 108	108A	STAINLESS STEEL SHELF			●				SUPPLIED BY NATIONAL ACCOUNT PLUMBING VENDOR AS PART OF G.C. SCOPE.
	108B	WATER FOUNTAIN			●	●	●	●	
SALON CHECK-IN 113	113A	FENCE AND GATE			●		●		***** SEE GENERAL NOTES ABOVE
	113B	TERMINAL CABINET			●	●			***** SEE GENERAL NOTES ABOVE
	113C	SERVICES CABINET			●	●			***** SEE GENERAL NOTES ABOVE
	113D	BENCH	●						
SALON 114	114A	CUTTING STATIONS			●				***** SEE GENERAL NOTES ABOVE
	114B	MIRRORS			●				***** SEE GENERAL NOTES ABOVE
	114C	CUTTING TABLES	●			●			
	114D	FLUFF DRYER	●			●			
DRYING AREA 115	115A	FLUFF DRYER	●			●			
	115B	MASTER BLASTER DRYER	●			●			
	115C	ROLLING CAGES	●						
	115D	STORAGE CABINET	●						
	115E	DRYING TABLES	●						
BATHING AREA 116	116A	PROPORTIONER			●		●	●	***** SEE GENERAL NOTES ABOVE
	116B	SHELVING			●				***** SEE GENERAL NOTES ABOVE
	116C	TUBS	●						G.C. RESPONSIBLE FOR HARD PIPE WASTE CONNECTION IF REQUIRED BY CODE.
	116D	EYE WASH	●						NO PLUMBING REQUIRED.
RECEIVING 117	117A	MOP SINK			●		●	●	SUPPLIED BY NATIONAL ACCOUNT PLUMBING VENDOR AS PART OF G.C. SCOPE.
	117B	CHEMICAL MIXING SYSTEM	●						G.C. RESPONSIBLE FOR BACKFLOW PREVENTER IF REQUIRED BY CODE.
	117C	BATTERY CHARGER		●		●			BATTERY CHARGER SUPPLIED BY PETSMART AND INSTALLED BY G.C. AND E.C. UNIT ARRIVES THE WEEK BEFORE THE MILLWORK DATE AND MUST BE INSTALLED IMMEDIATELY.
	117D	EYE WASH	●						NO PLUMBING REQUIRED.
	117E	FLOOR SCRUBBER	●			●	●		FLOOR DRAIN ONLY IS REQUIRED.
	117F	RECEIVING AREA RACKING	●						
ADOPTIONS MEET & GREET 118	118A	BENCH	●						
	118B	WIRE SHELF	●						
	118C	ROLLING ADOPTIONS DESK			●				***** SEE GENERAL NOTES ABOVE (PAID FOR BY PETSMART)
ADOPTIONS 119	119A	ADOPTION CAGES			●				***** SEE GENERAL NOTES ABOVE
	119B	SINK CABINET			●		●	●	***** SEE GENERAL NOTES ABOVE
FISH PREP 120	120A	FISH REFRIGERATOR	●			●			
	120B	SHELVING			●				***** SEE GENERAL NOTES ABOVE
	120C	STAINLESS STEEL TABLE			●				***** SEE GENERAL NOTES ABOVE
	120D	STAINLESS STEEL SHELF			●				***** SEE GENERAL NOTES ABOVE
	120E	WATER FILTRATION SYSTEM	●				●	●	
	120F	CHEMICAL MIXING SYSTEM	●						G.C. RESPONSIBLE FOR BACKFLOW PREVENTER IF REQUIRED BY CODE.
120G	EYE WASH	●						NO PLUMBING REQUIRED.	
FISH EQUIPMENT 121	121A	BAG STATION			●				***** SEE GENERAL NOTES ABOVE (PAID FOR BY PETSMART)
	121B	FISH TANK DISPLAY	●			●			ANCHORED BY FISH EQUIPMENT SUPPLIER.
	121C	FISH FREEZER	●			●			
HOLDING #2 122	122A	SHELVING			●				***** SEE GENERAL NOTES ABOVE
	122B	QUARANTINE CAGE			●				***** SEE GENERAL NOTES ABOVE (PAID FOR BY PETSMART)
	122C	HOLDING CAGE			●				***** SEE GENERAL NOTES ABOVE (PAID FOR BY PETSMART)
HOLDING #1 123	123A	SHELVING			●				***** SEE GENERAL NOTES ABOVE
	123B	QUARANTINE CAGE			●				***** SEE GENERAL NOTES ABOVE (PAID FOR BY PETSMART)
	123C	TANK	●						

DESIGNED BY: [Signature] 10/1/2024



TENANT: PETSMART 19601 North 27th Avenue Phoenix, Arizona 85027 - (623) 580-6100		
PROJECT: 18K 2025 U.S. VET SERVICES INSTRUCTION SET FEBRUARY 12, 2025		
ARCHITECT:		
CONSULTANT:		
SEAL:		
CITY SEAL:		
DISCLAIMER: THIS DRAWING AND DESIGN IS IN COPYRIGHT PROTECTED WHICH SHALL NOT BE USED, REPRODUCED OR REVISED WITHOUT WRITTEN PERMISSION BY PETSMART. THE CONTRACTOR SHALL CHECK AND VERIFY ALL DIMENSIONS AND UTILITY LOCATIONS AND REPORT ALL ERRORS AND OMISSIONS PRIOR TO COMMENCING WORK. THIS DRAWING IS NOT TO BE SCALED.		
ISSUED FOR:		
#	DESCRIPTION	DATE
PROJECT NO. 18K 2025 US INSTRUCTION SET		
ORIGINAL SCALE: AS INDICATED		IF THIS BAR IS NOT 1" LONG, ADJUST YOUR PLOTTING SCALE 
DRAWN BY:	XXX	
CHECKED BY:	XXX	
PAGE #:	OF:	
01	56	1"
DISCIPLINE: ARCHITECTURAL		
TITLE: FIXTURE REFERENCE PLAN		
SHEET NUMBER: F1.0		