




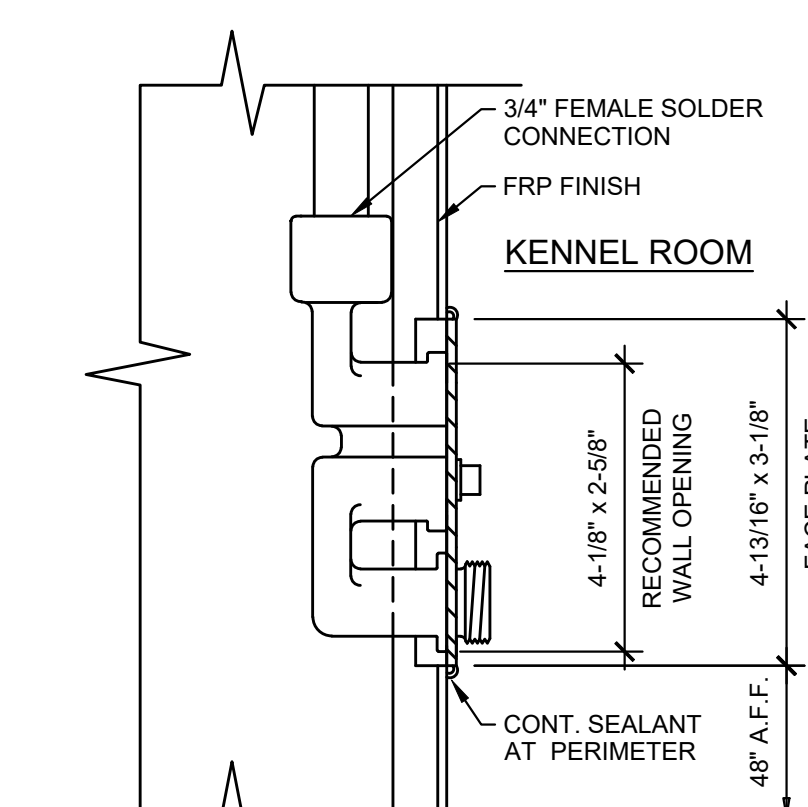


20 HOSE BIBB INSTALLATION AT KENNEL ROOM (HB-2)
P2.0 SCALE: N.T.S.

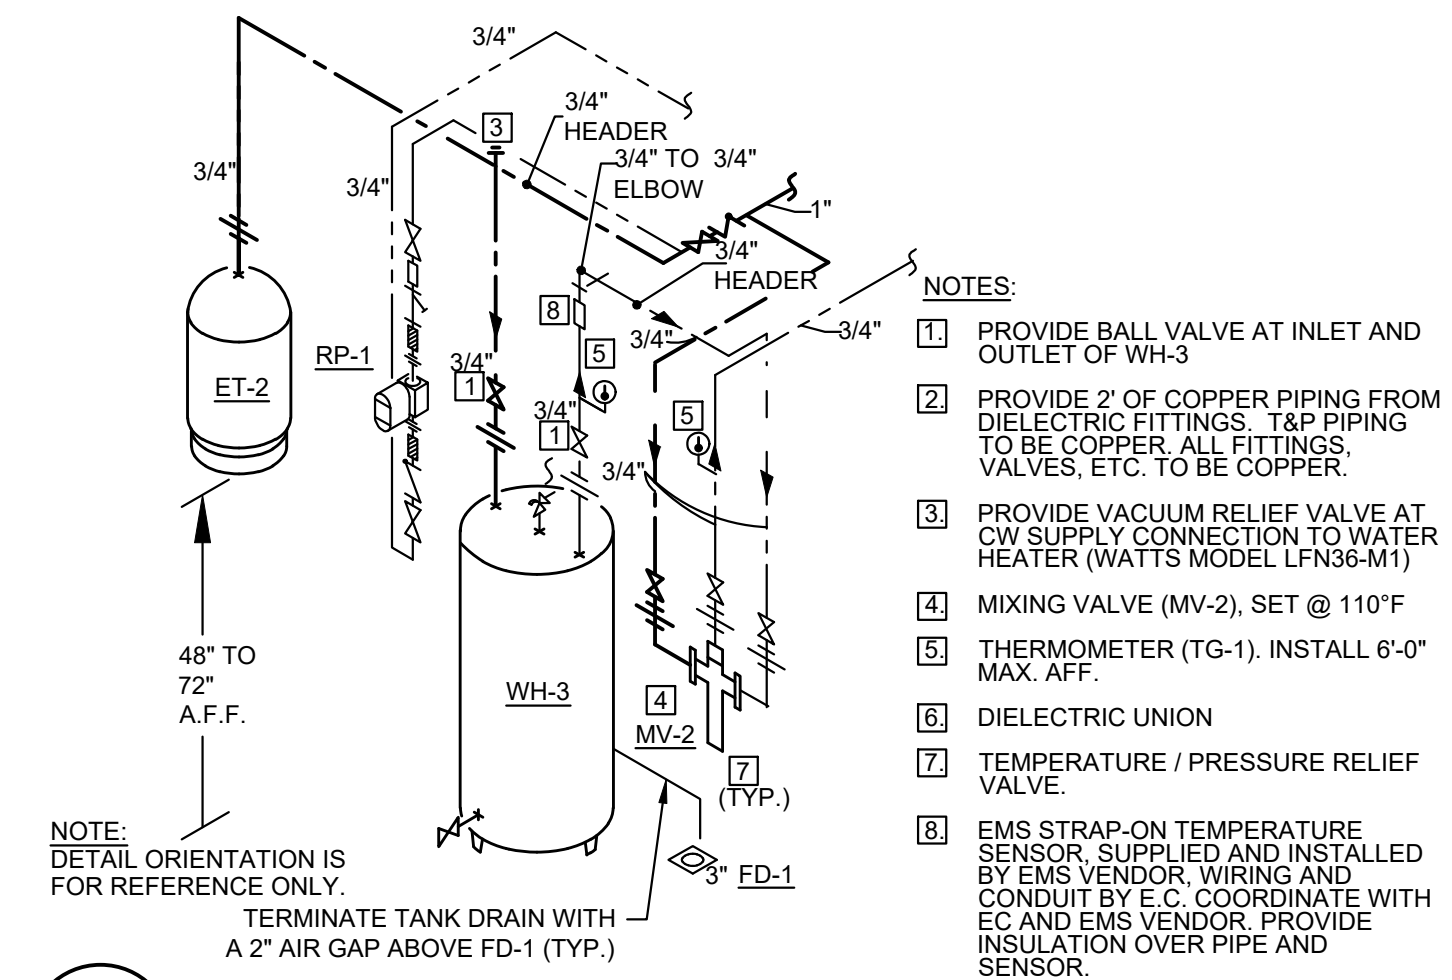


19 WATER HEATER INSTALLATION (WH-3)
P2.0 SCALE: N.T.S.

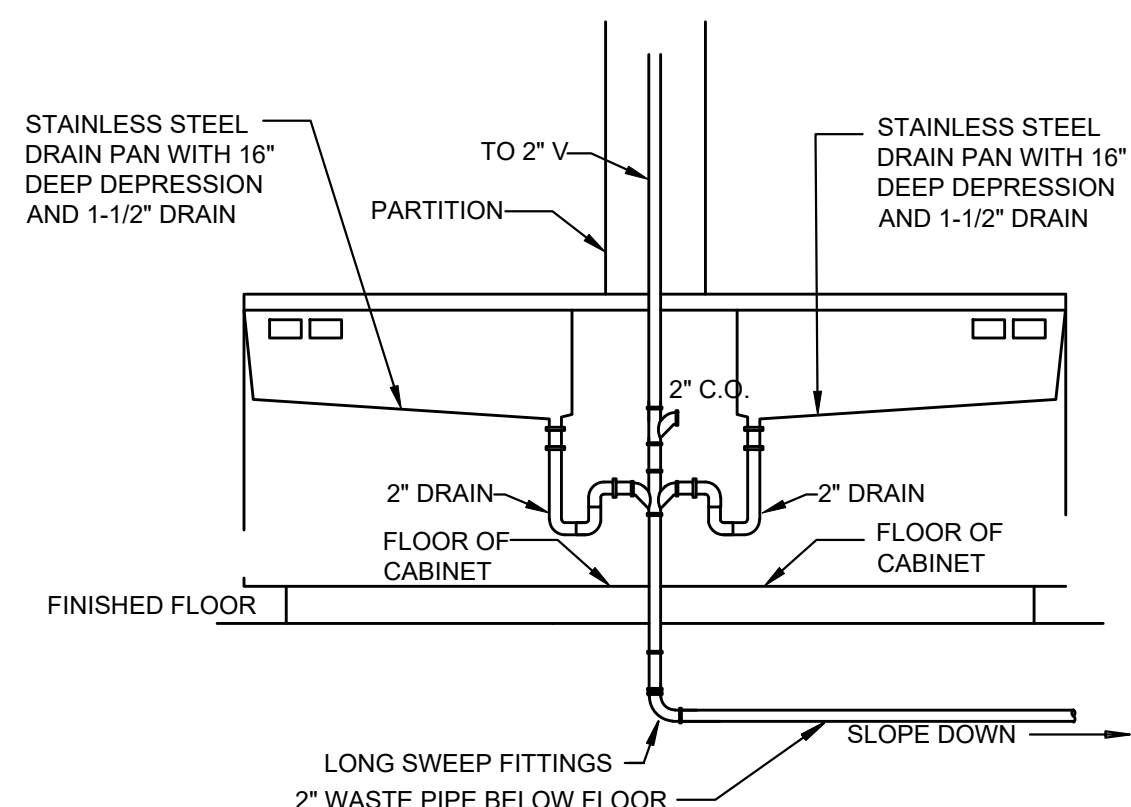


18 WASTE PIPING AT TREATMENT TABLE
P2.0 SCALE: N.T.S.

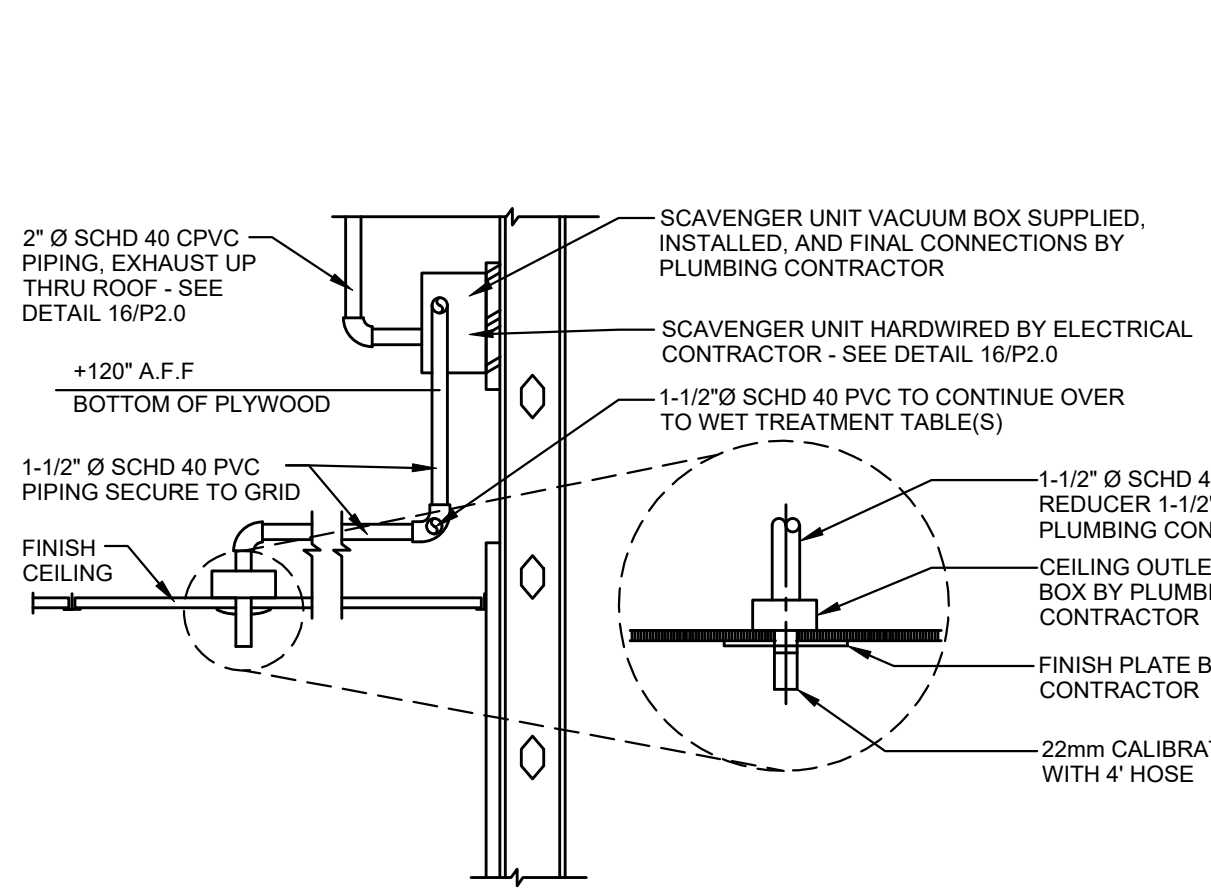


17 SCAVENGER PIPING TO DROP
P2.0 SCALE: N.T.S.

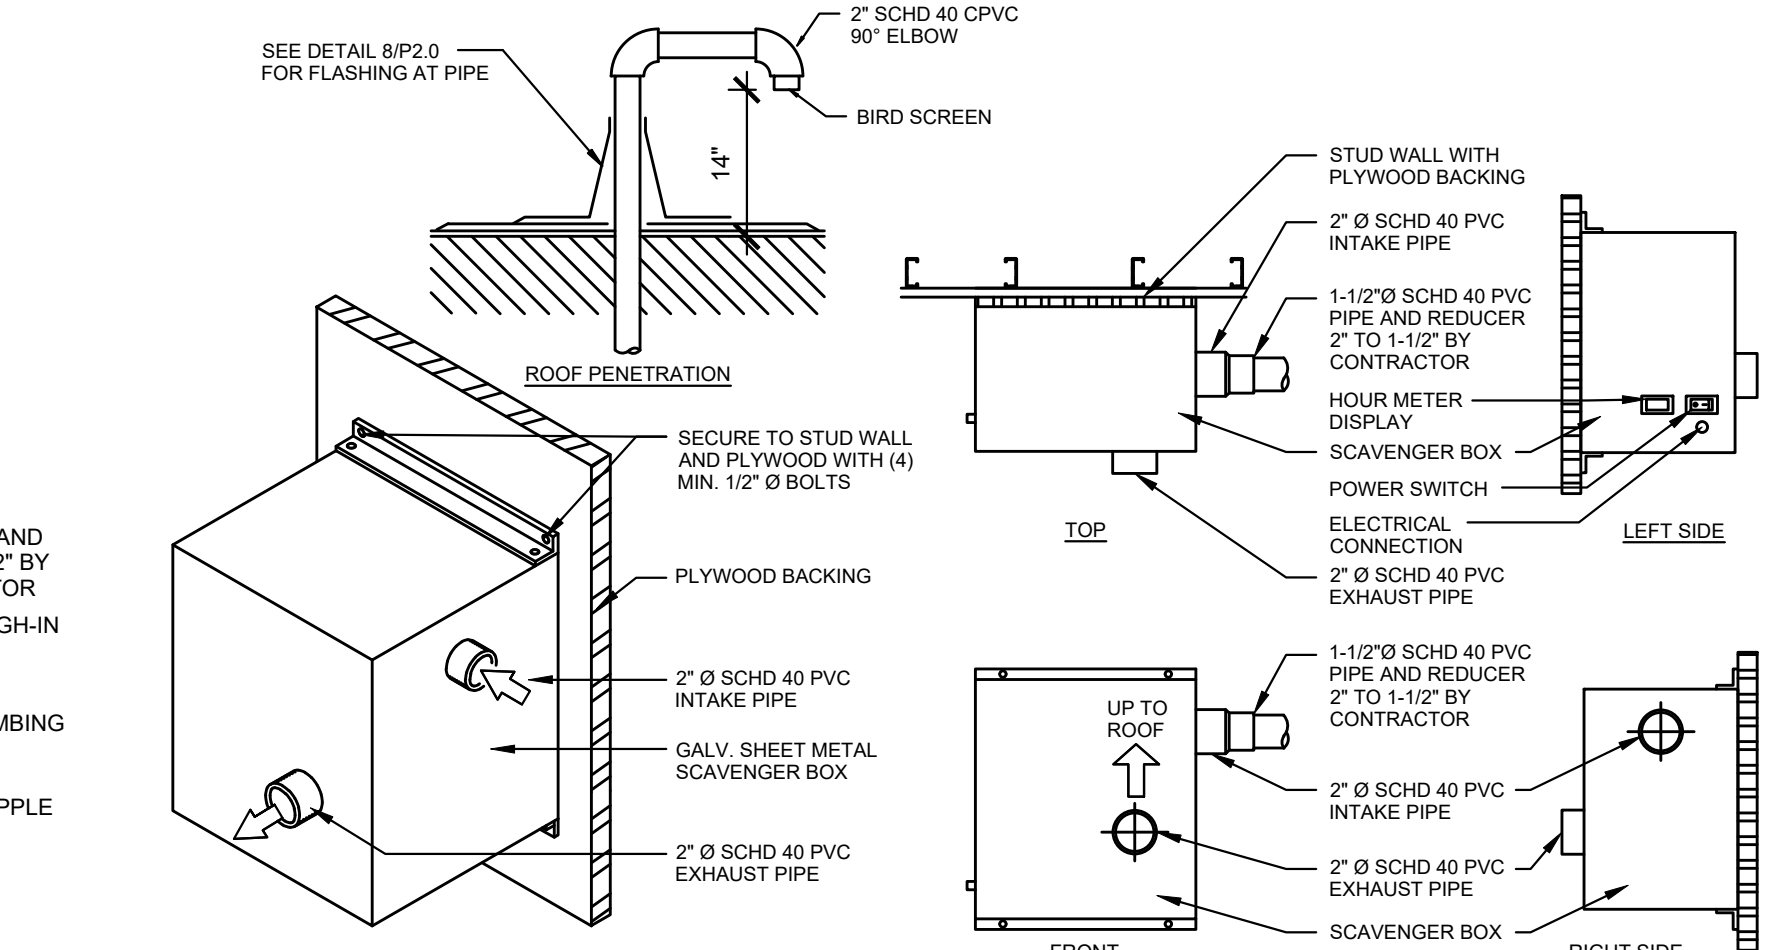


16 SCAVENGER VACUUM BOX
P2.0 SCALE: N.T.S.

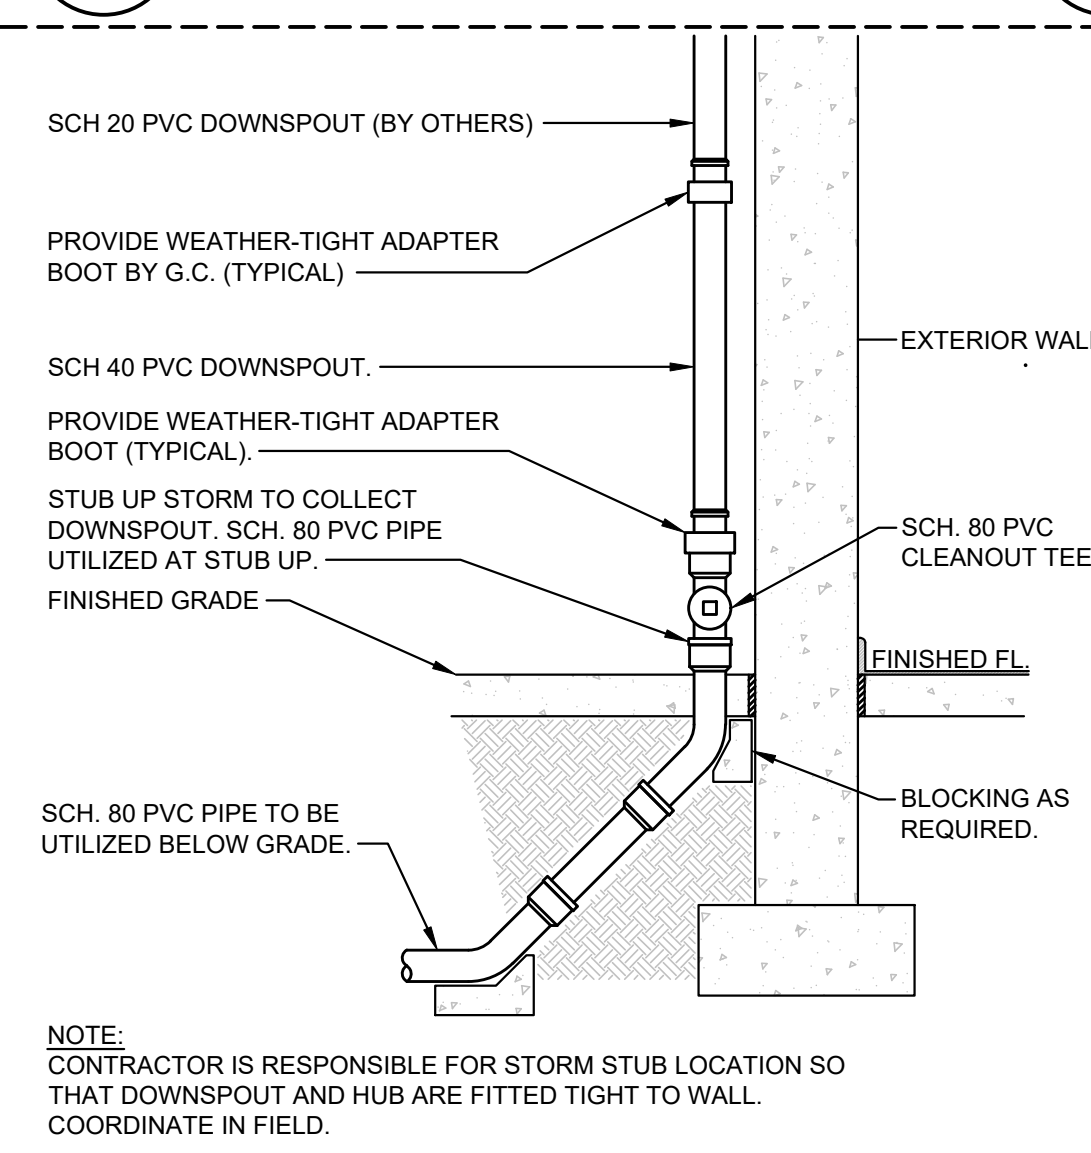


15 DOWNSPOUT SHOE INSTALLATION
P2.0 SCALE: N.T.S.

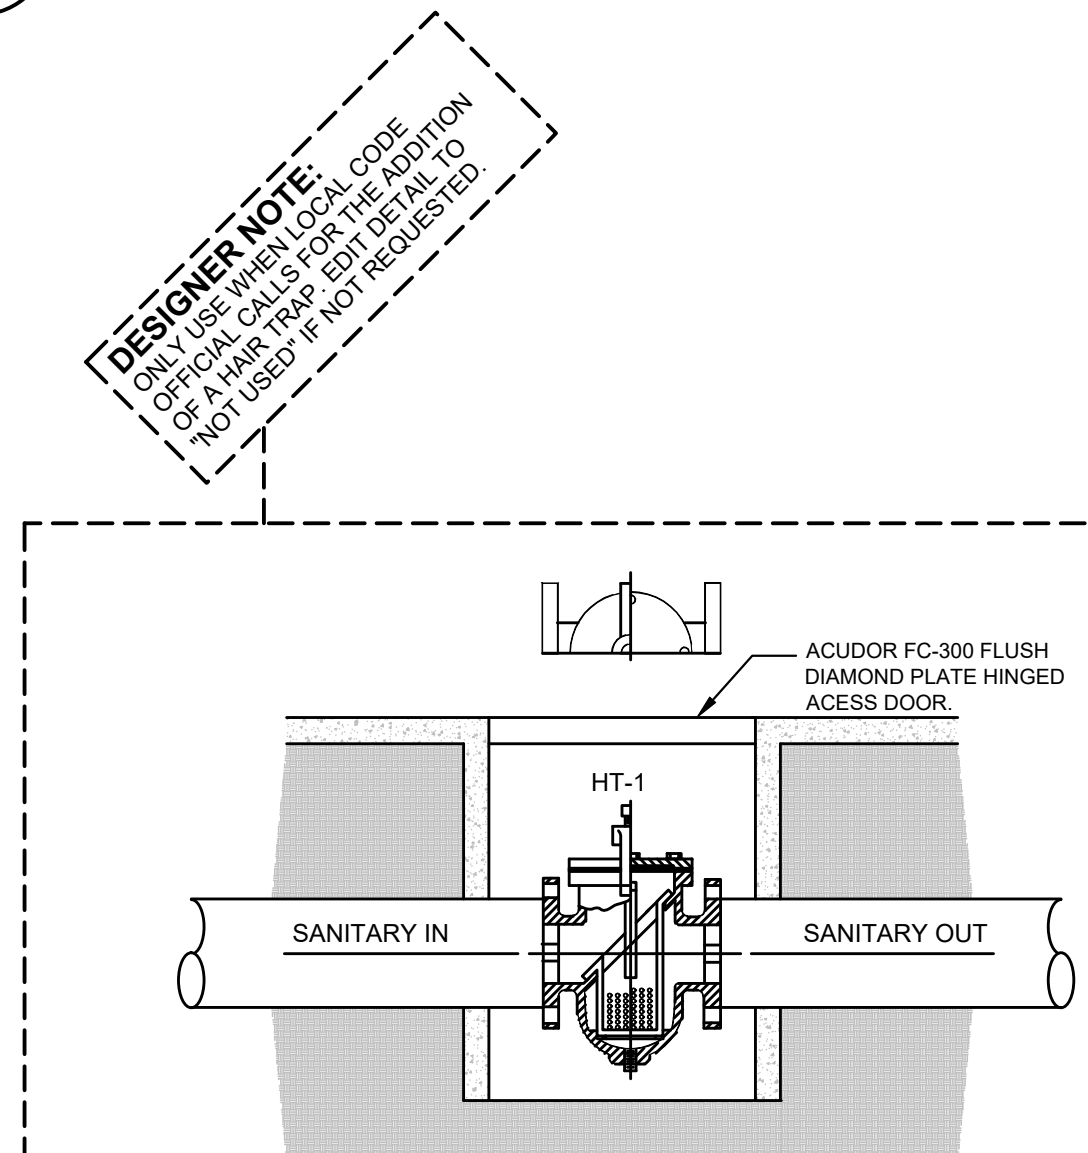


14 HAIR TRAP INSTALLATION
P2.0 SCALE: N.T.S.

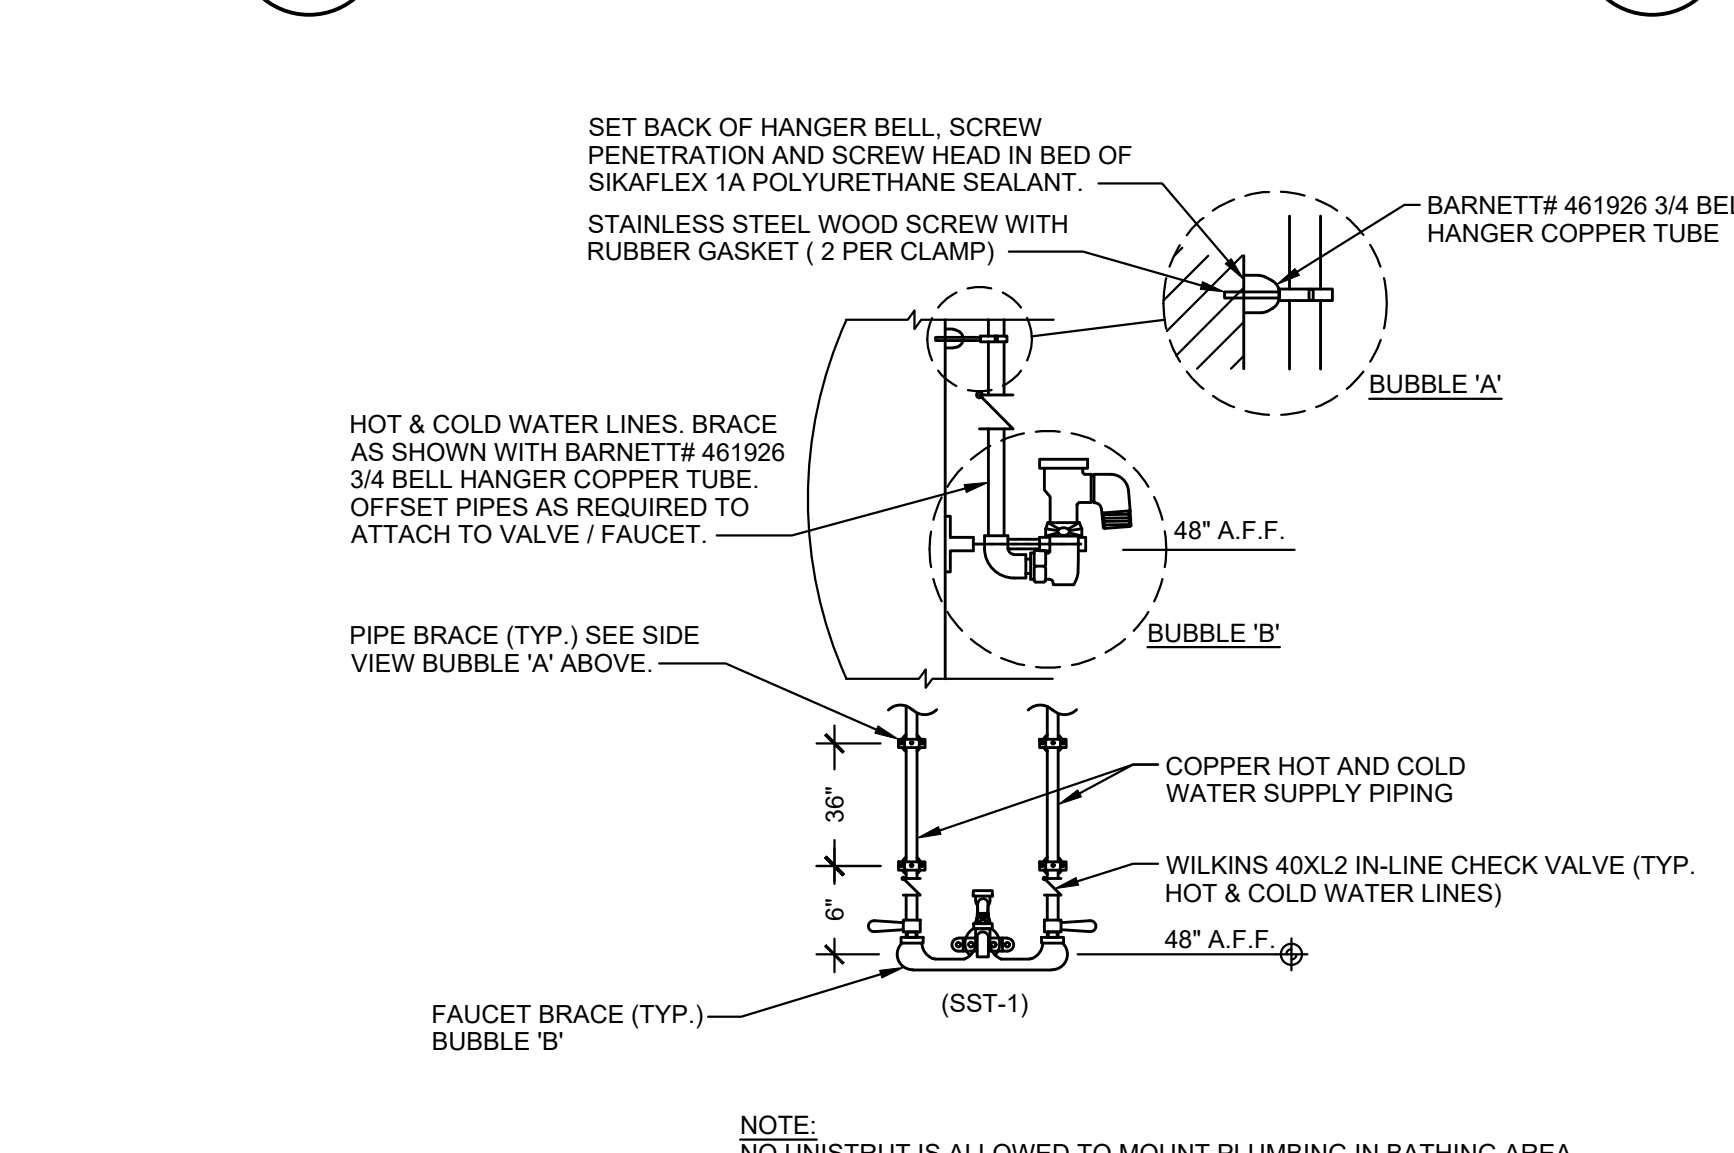


13 BATHING FAUCET INSTALLATION (SST-1)
P2.0 SCALE: N.T.S.

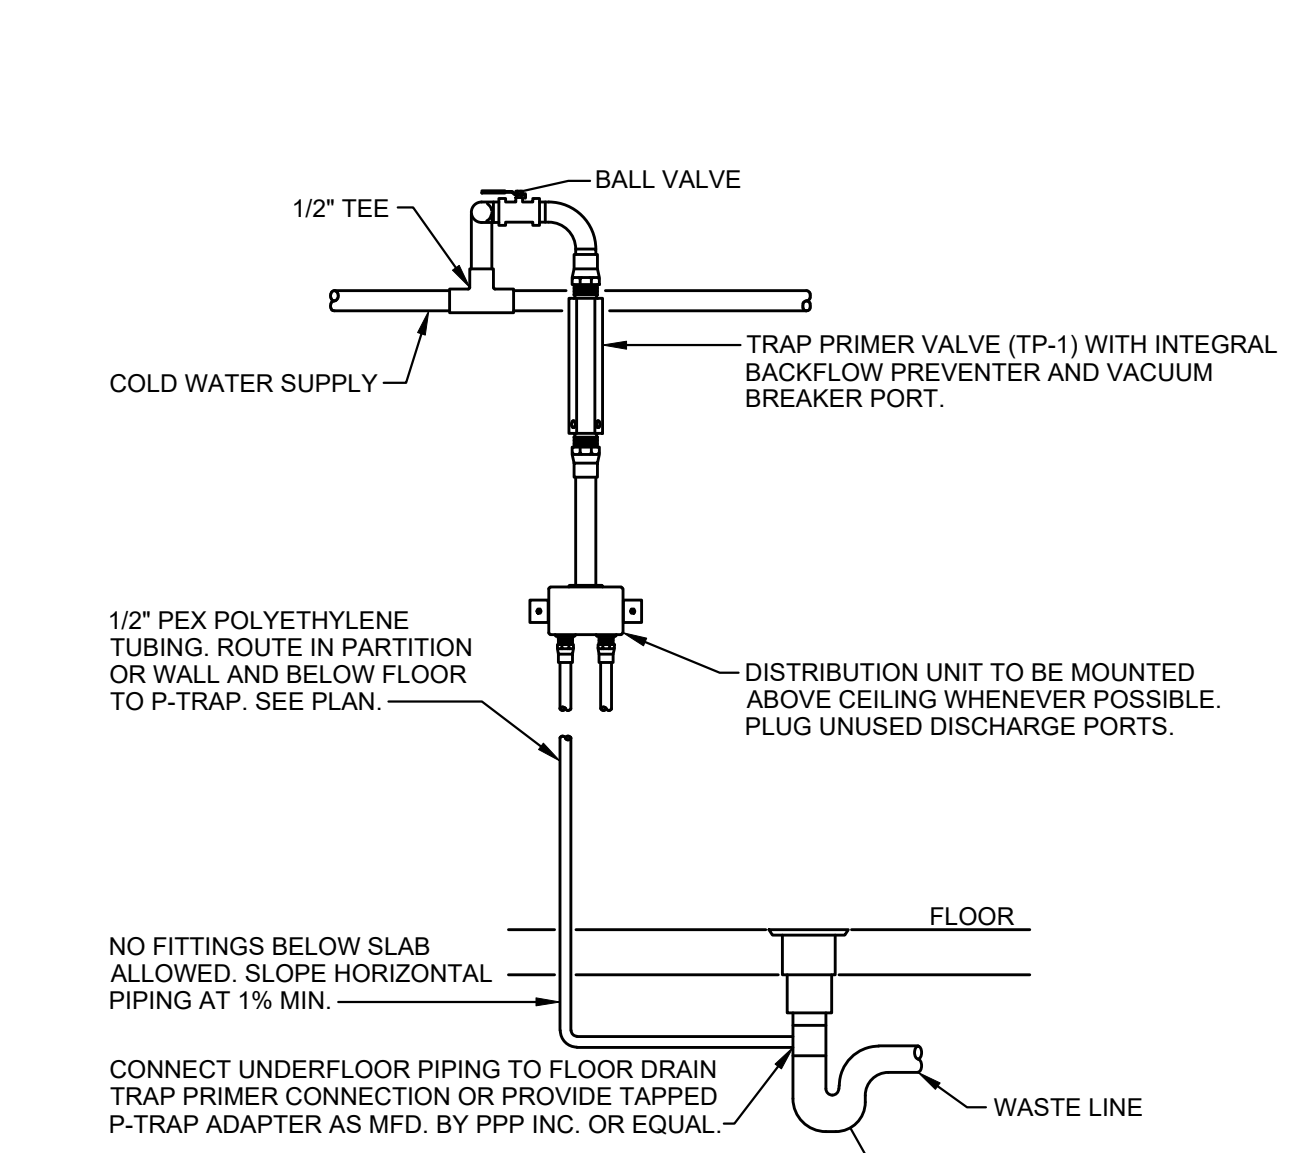


12 TRAP PRIMER INSTALLATION (TP-1)
P2.0 SCALE: N.T.S.

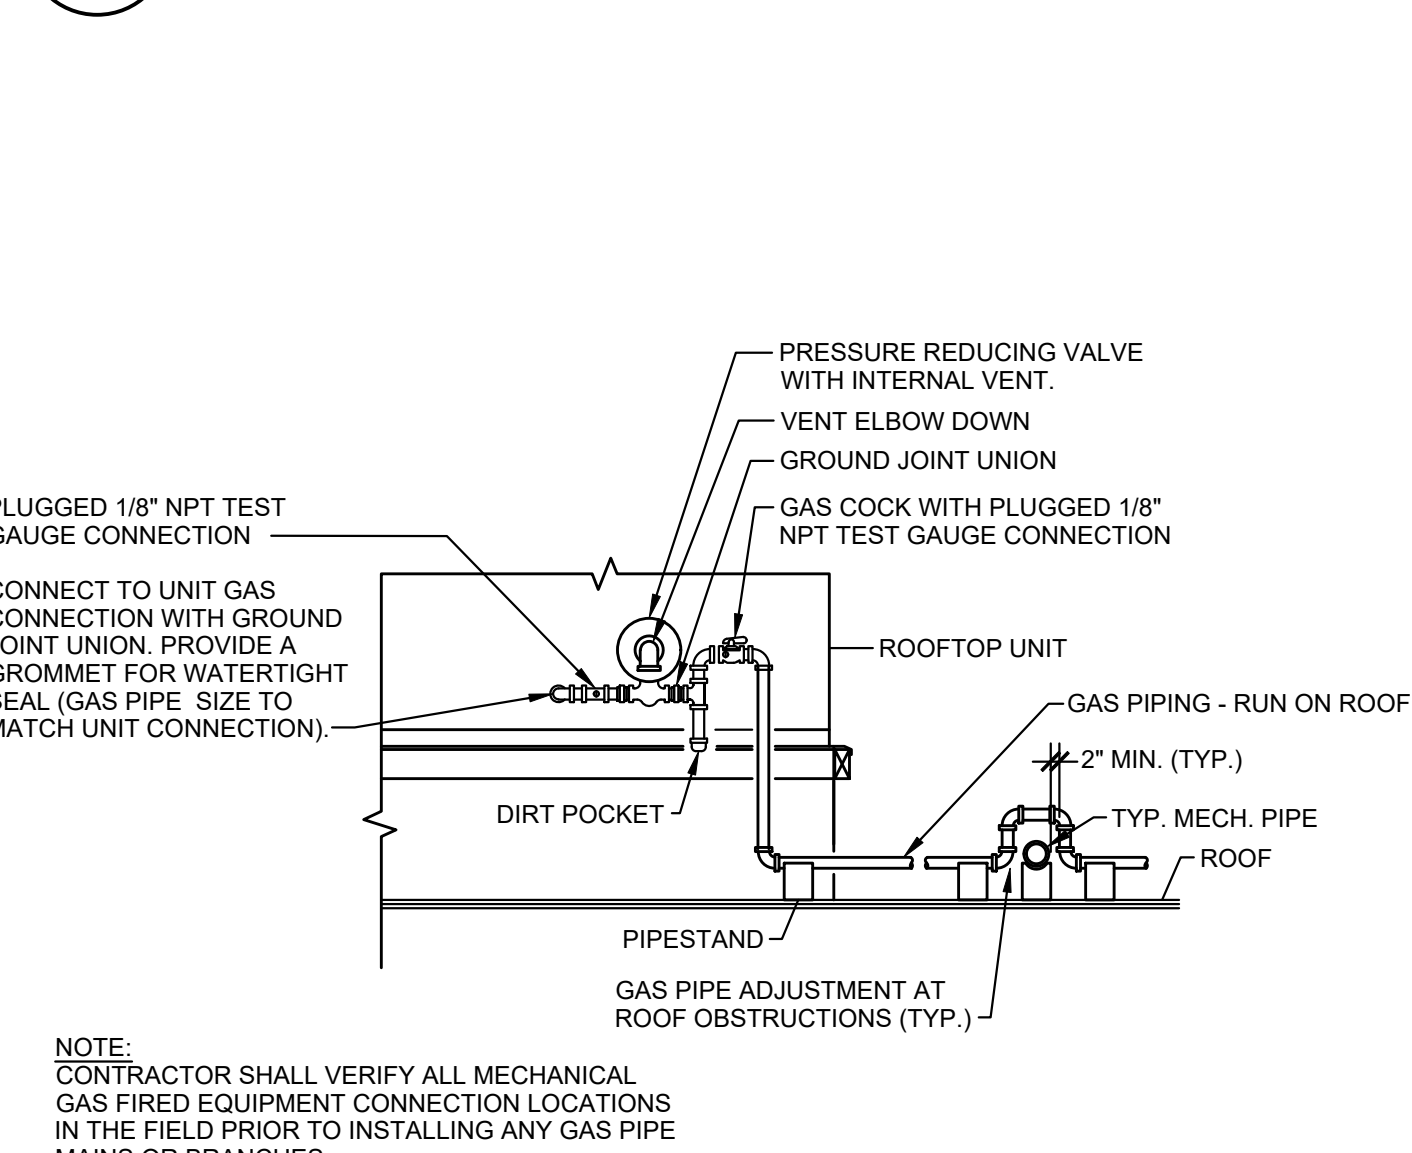


11 TYPICAL RTU GAS PIPING CONNECTION
P2.0 SCALE: N.T.S.

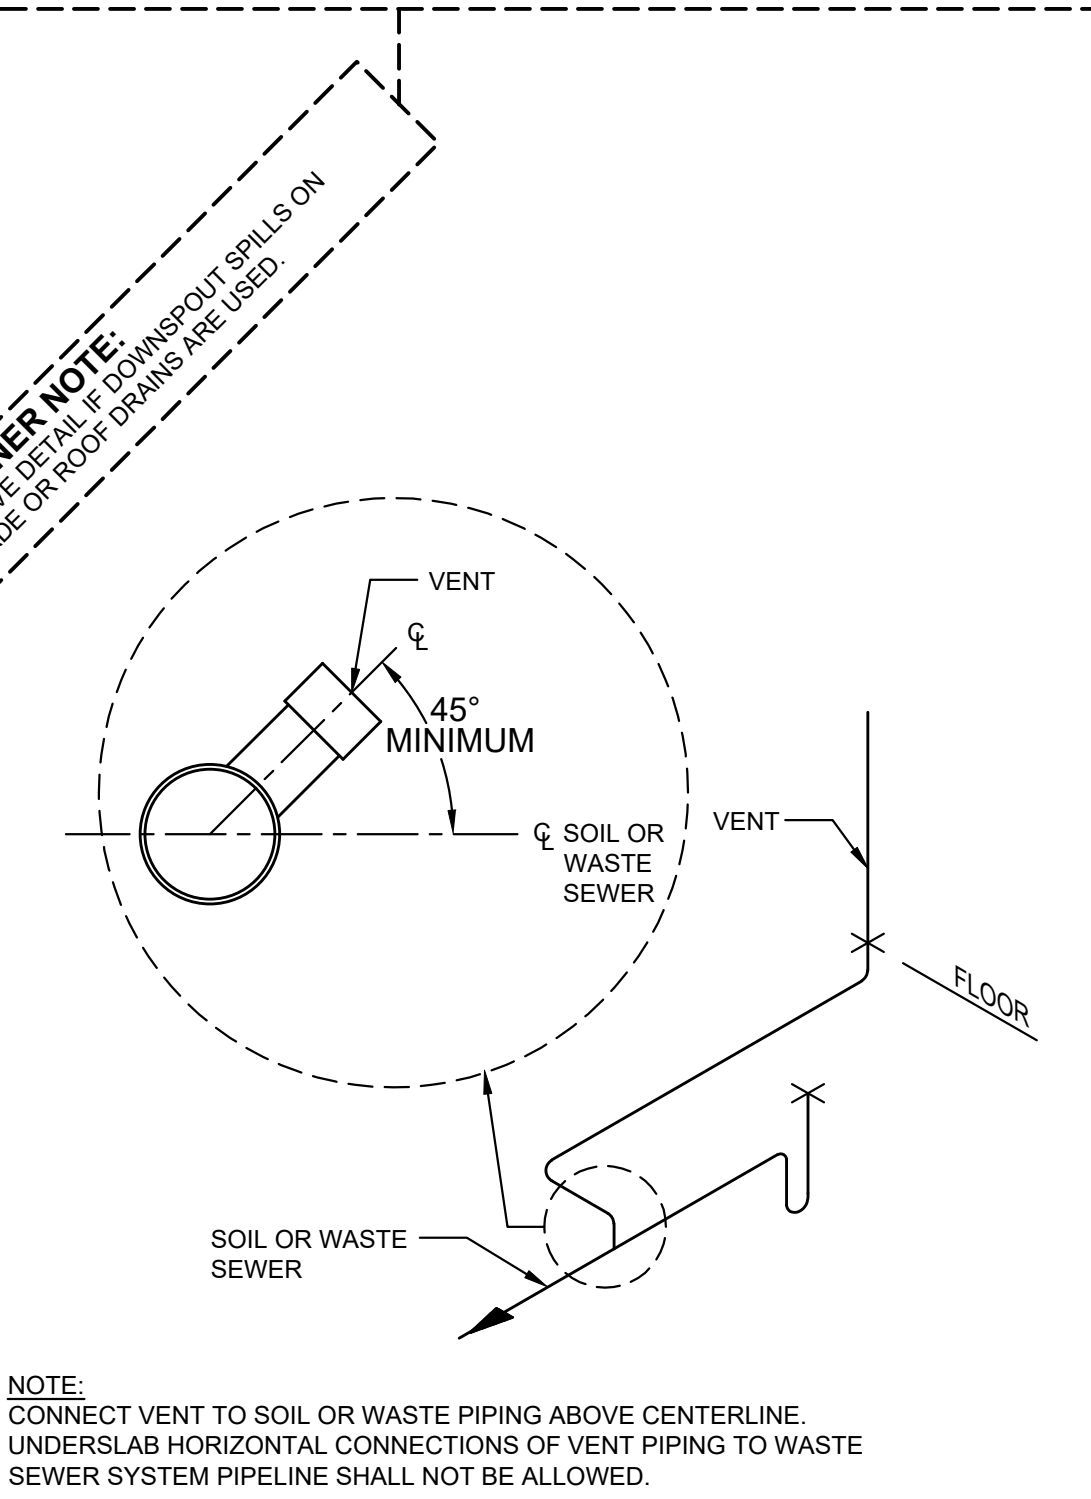


10 VENT PIPING INSTALLATION
P2.0 SCALE: N.T.S.

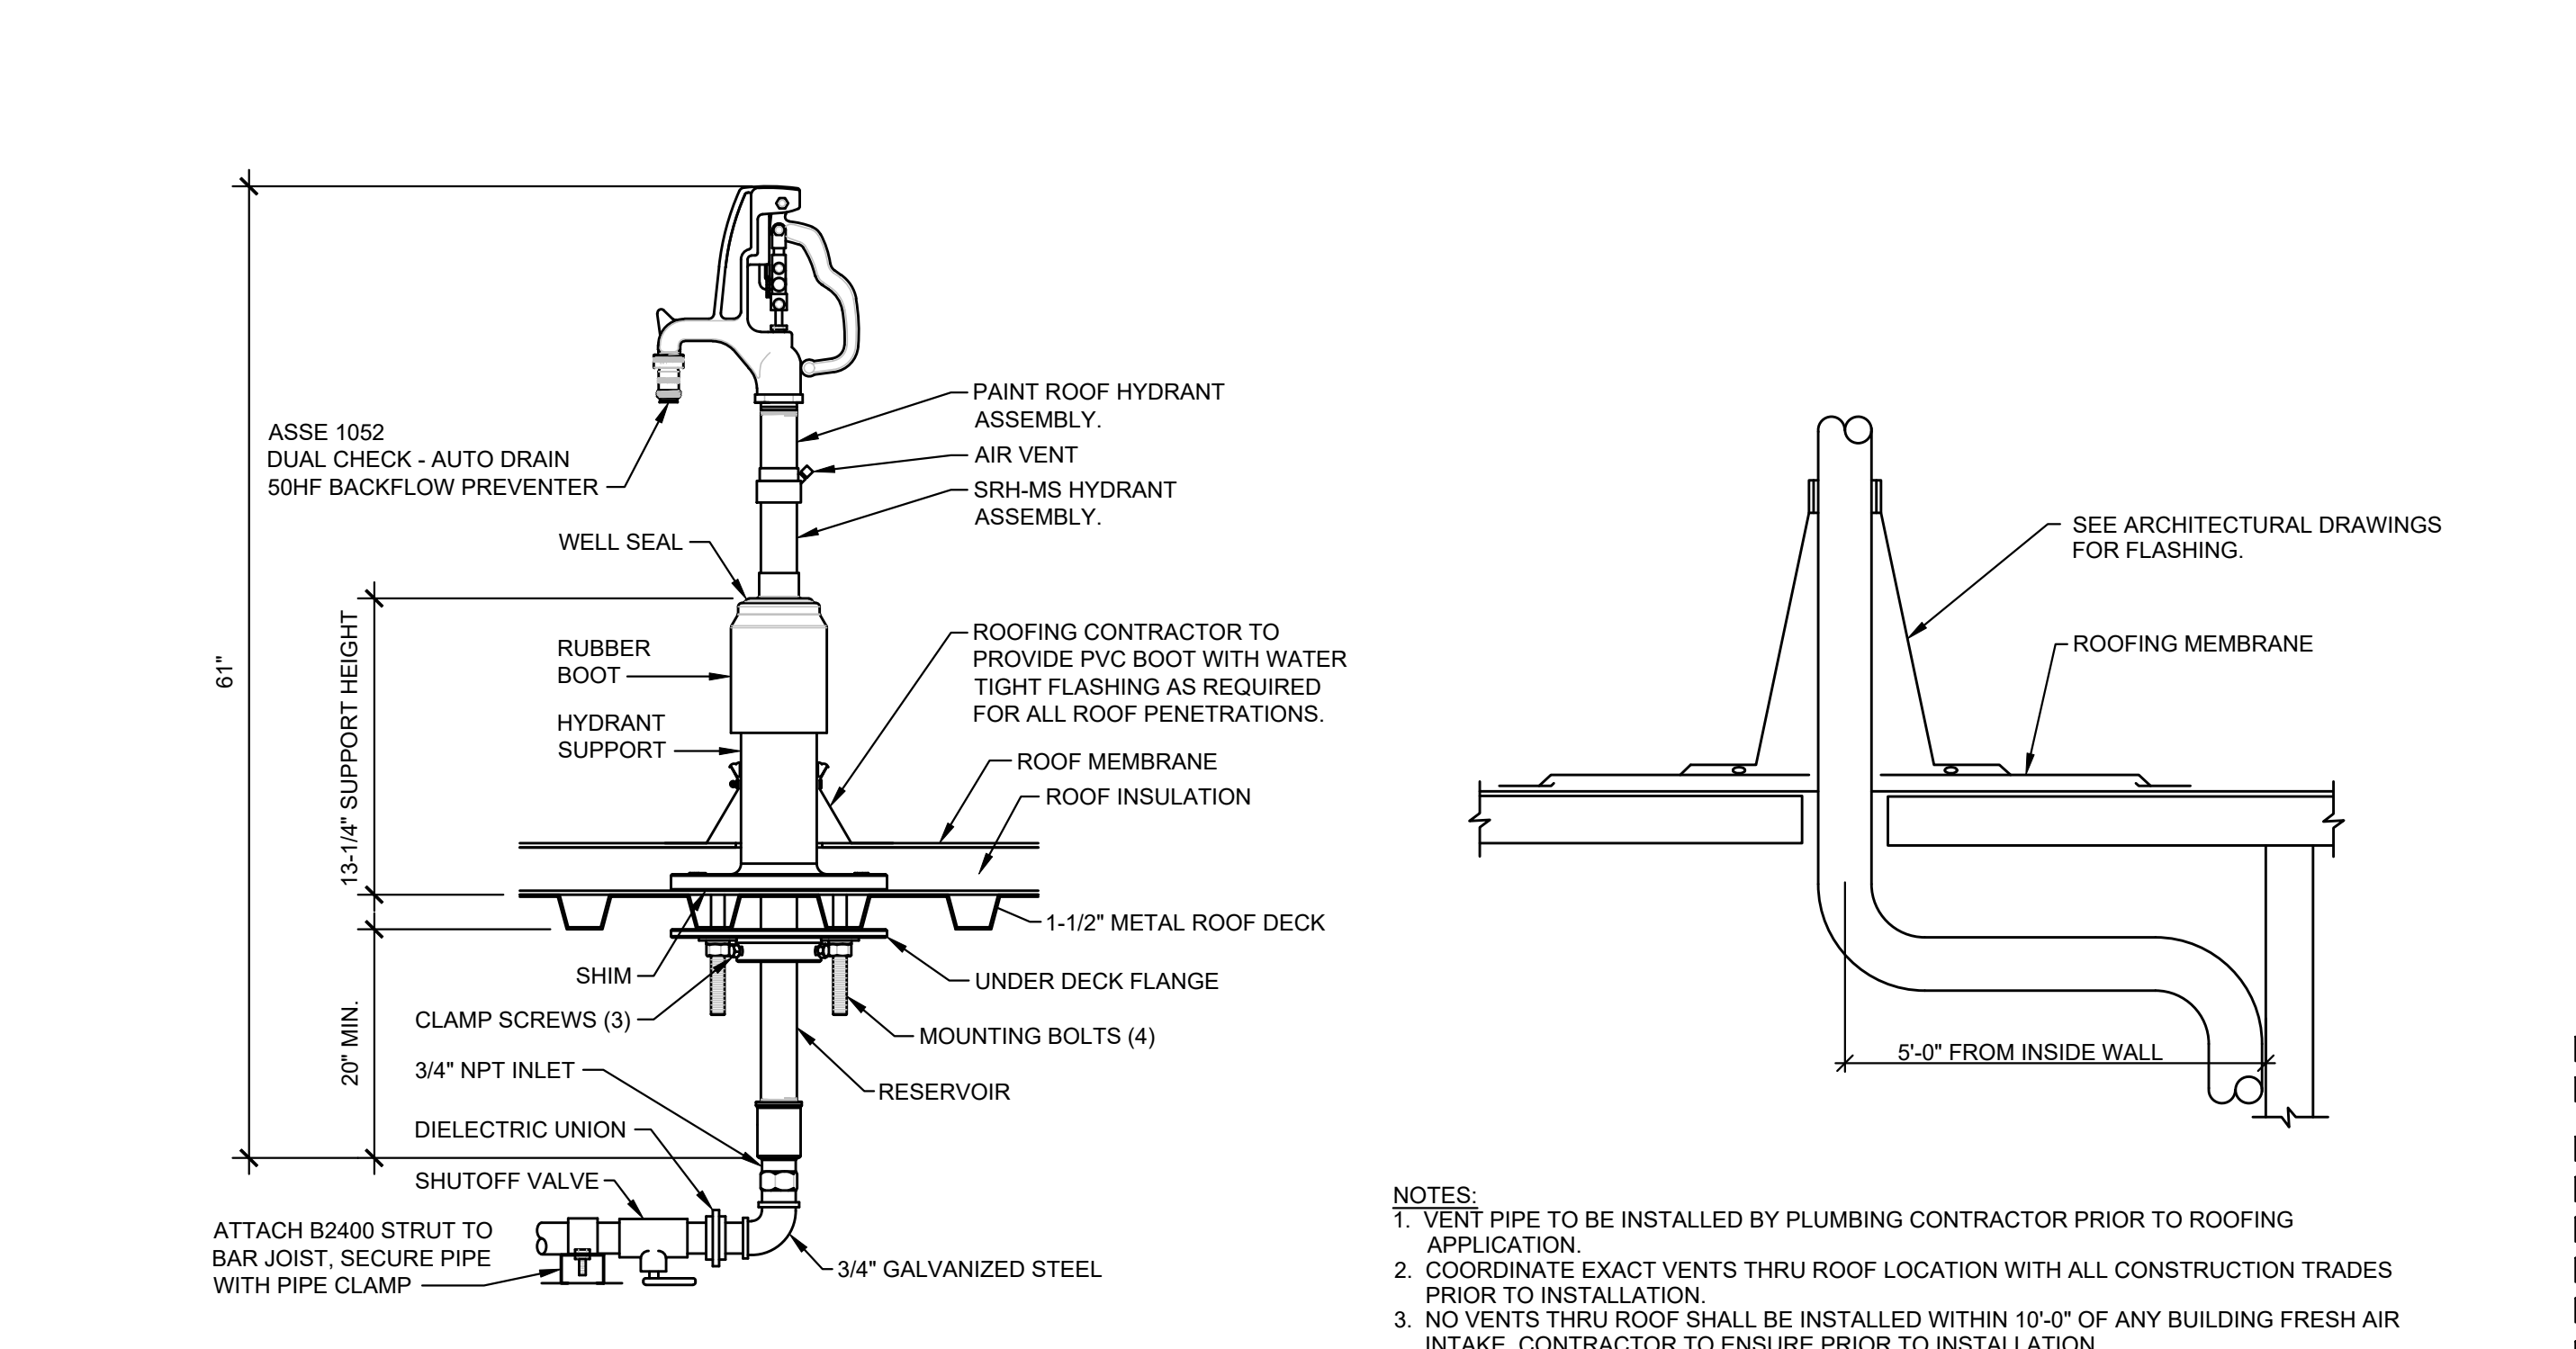


9 ROOF HYDRANT INSTALLATION (RH-1)
P2.0 SCALE: N.T.S.

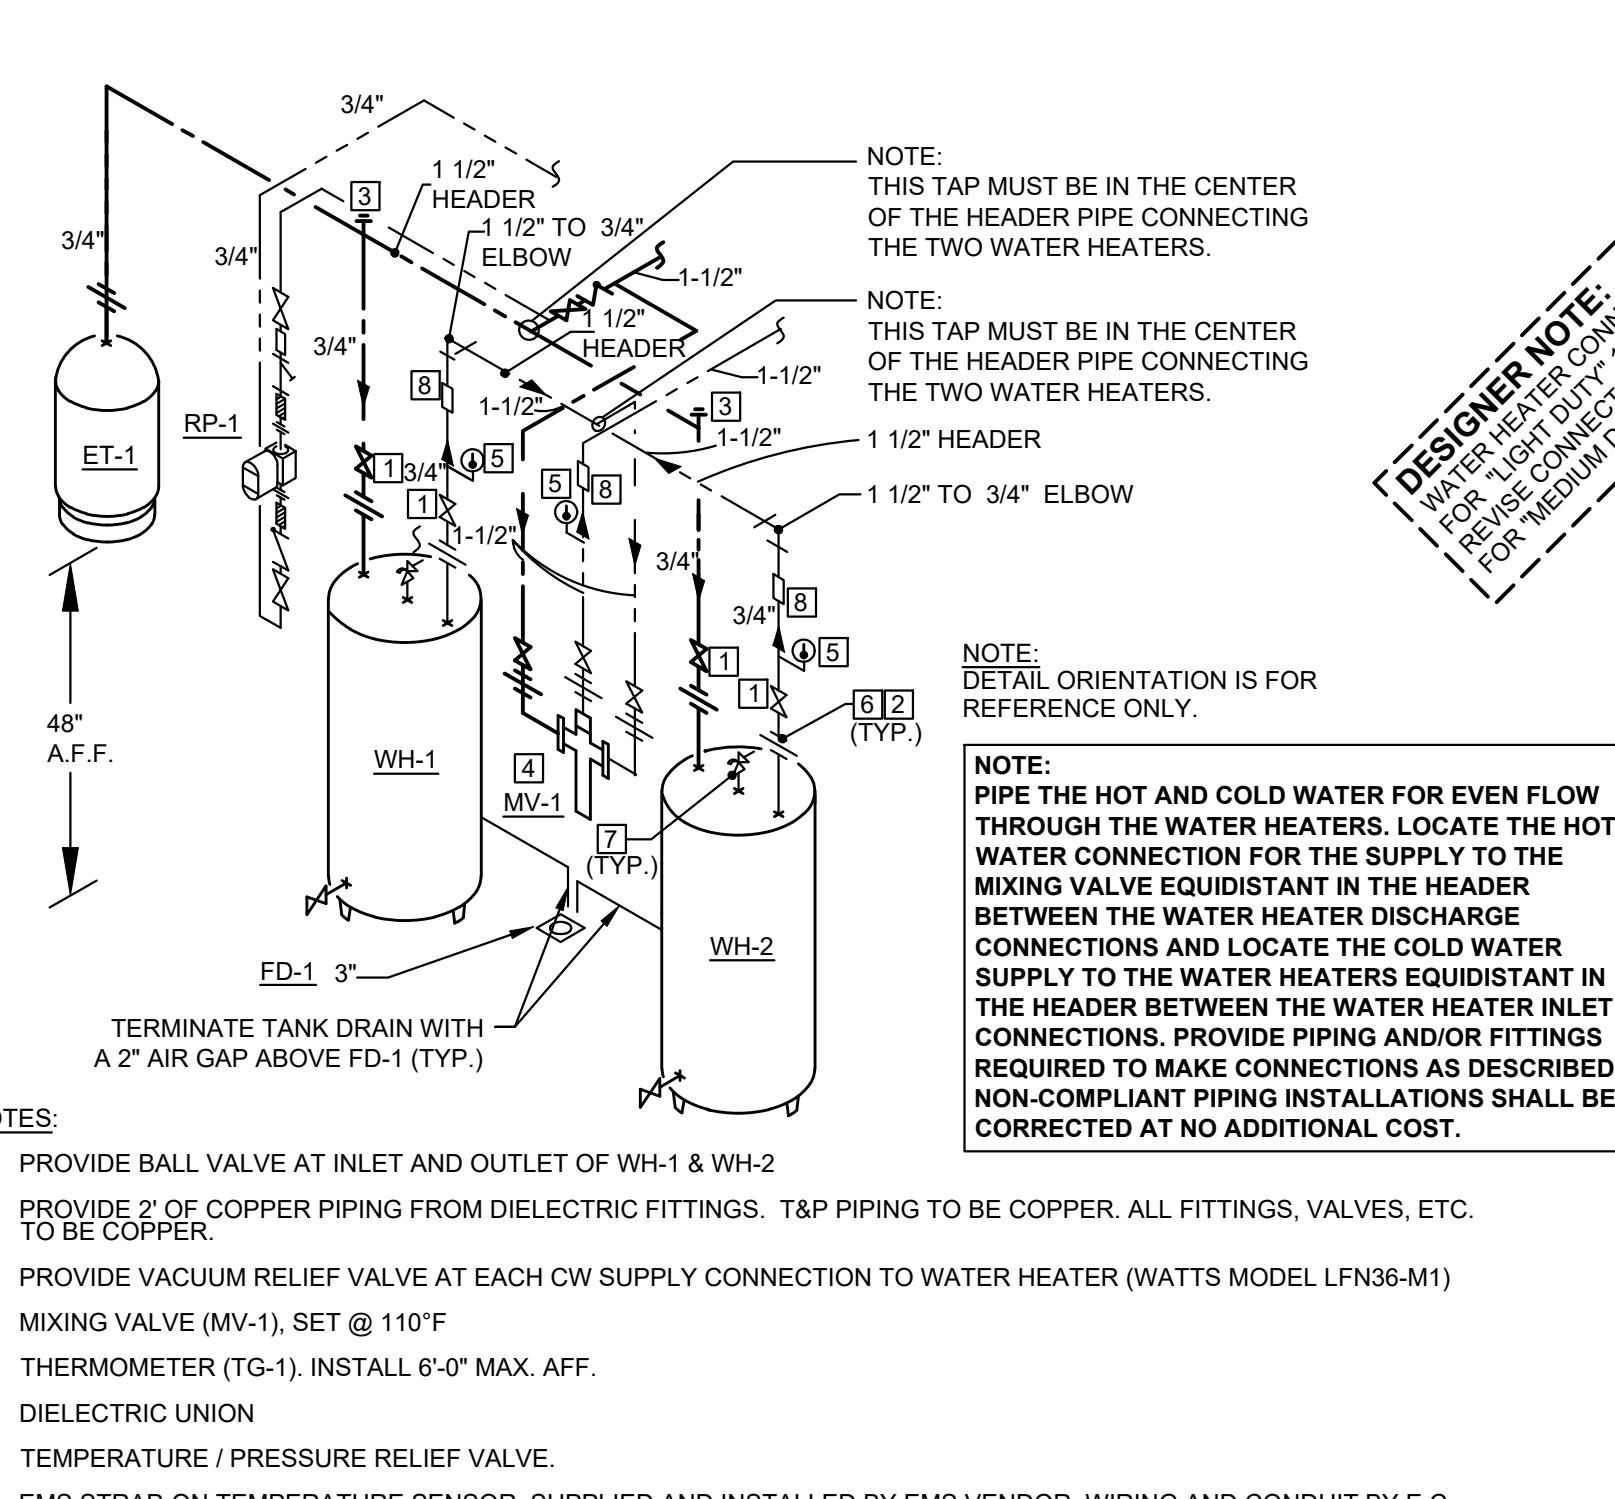


7 WATER HEATER INSTALLATION (WH-1 & 2)
P2.0 SCALE: N.T.S.

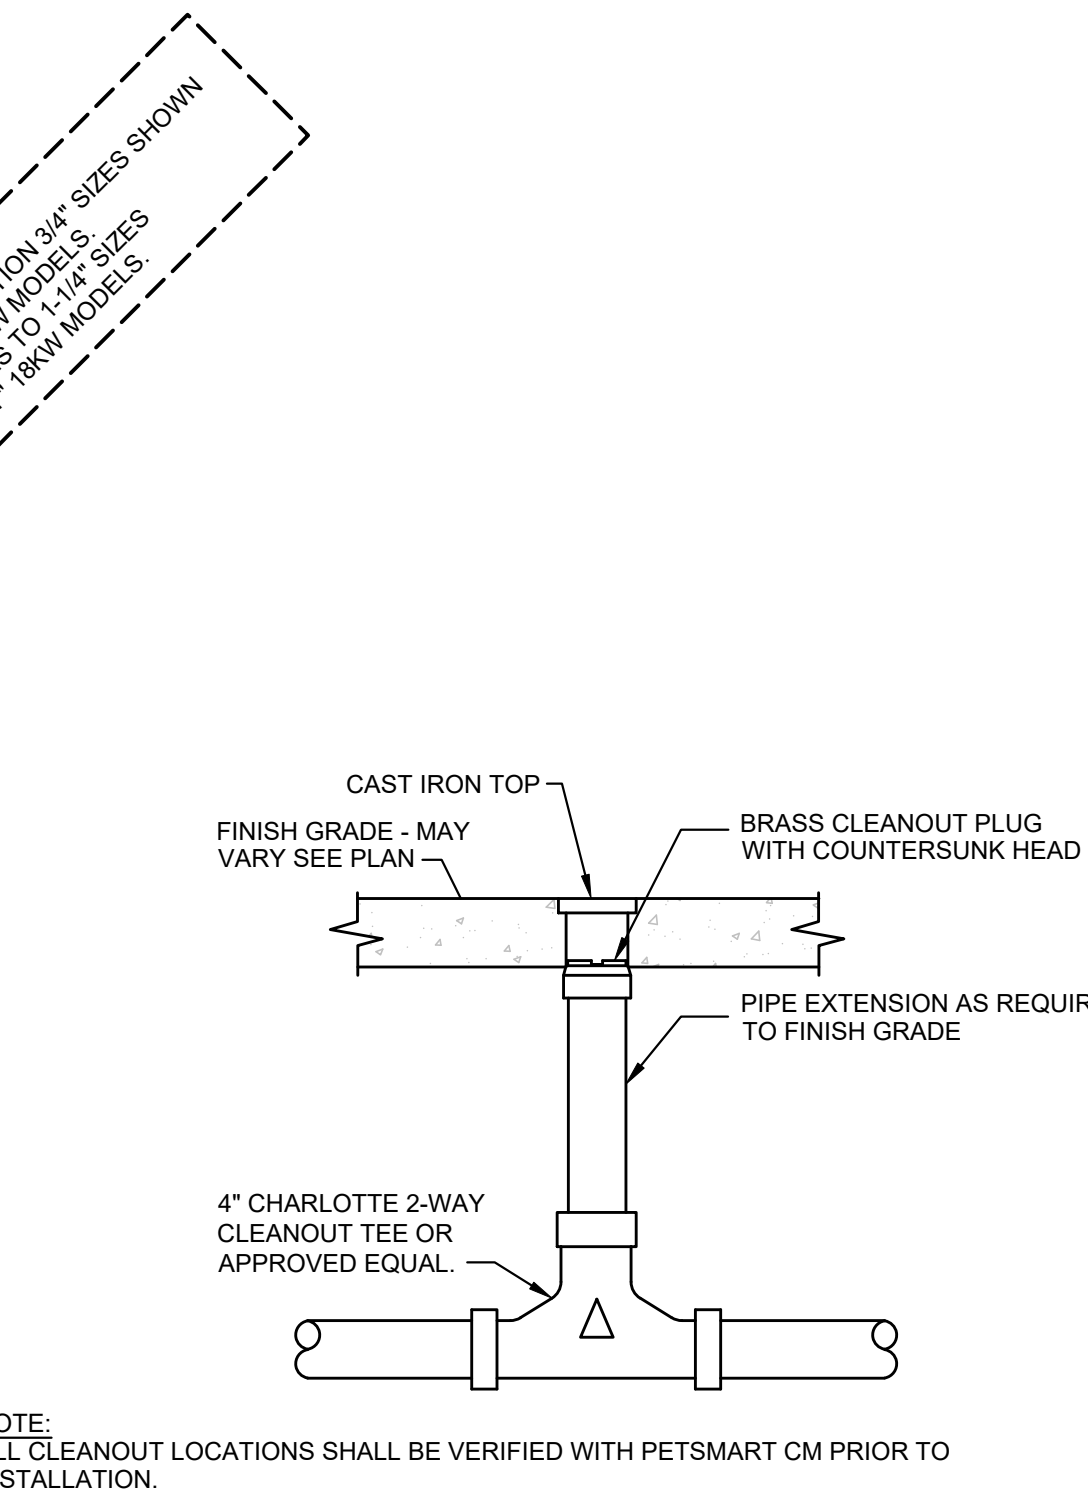


6 TYPICAL TWO-WAY CLEANOUT
P2.0 SCALE: N.T.S.

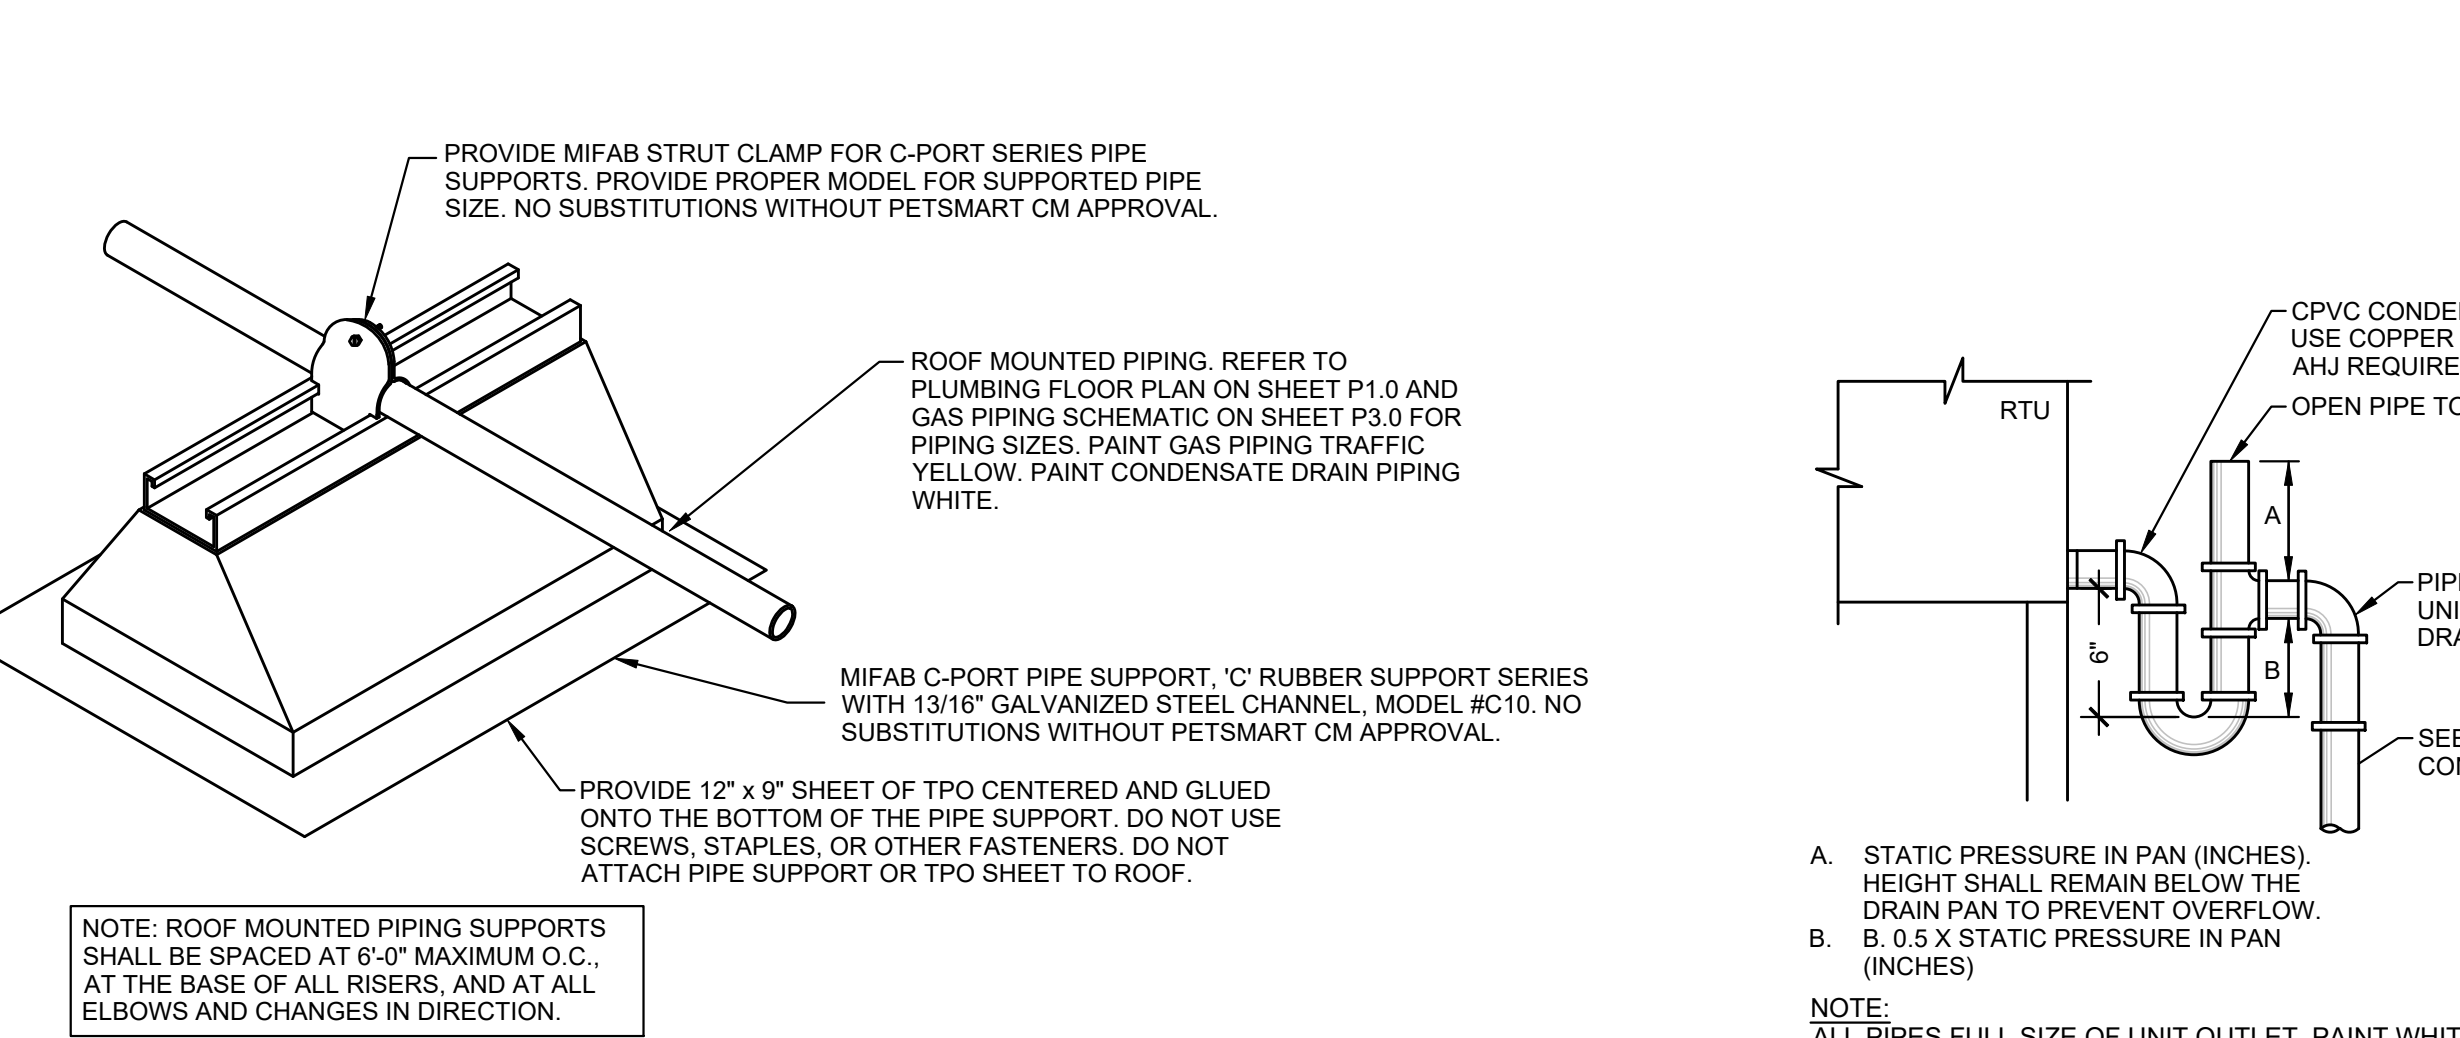


5 TYPICAL ROOF MOUNTED PIPING SUPPORT
P2.0 SCALE: N.T.S.

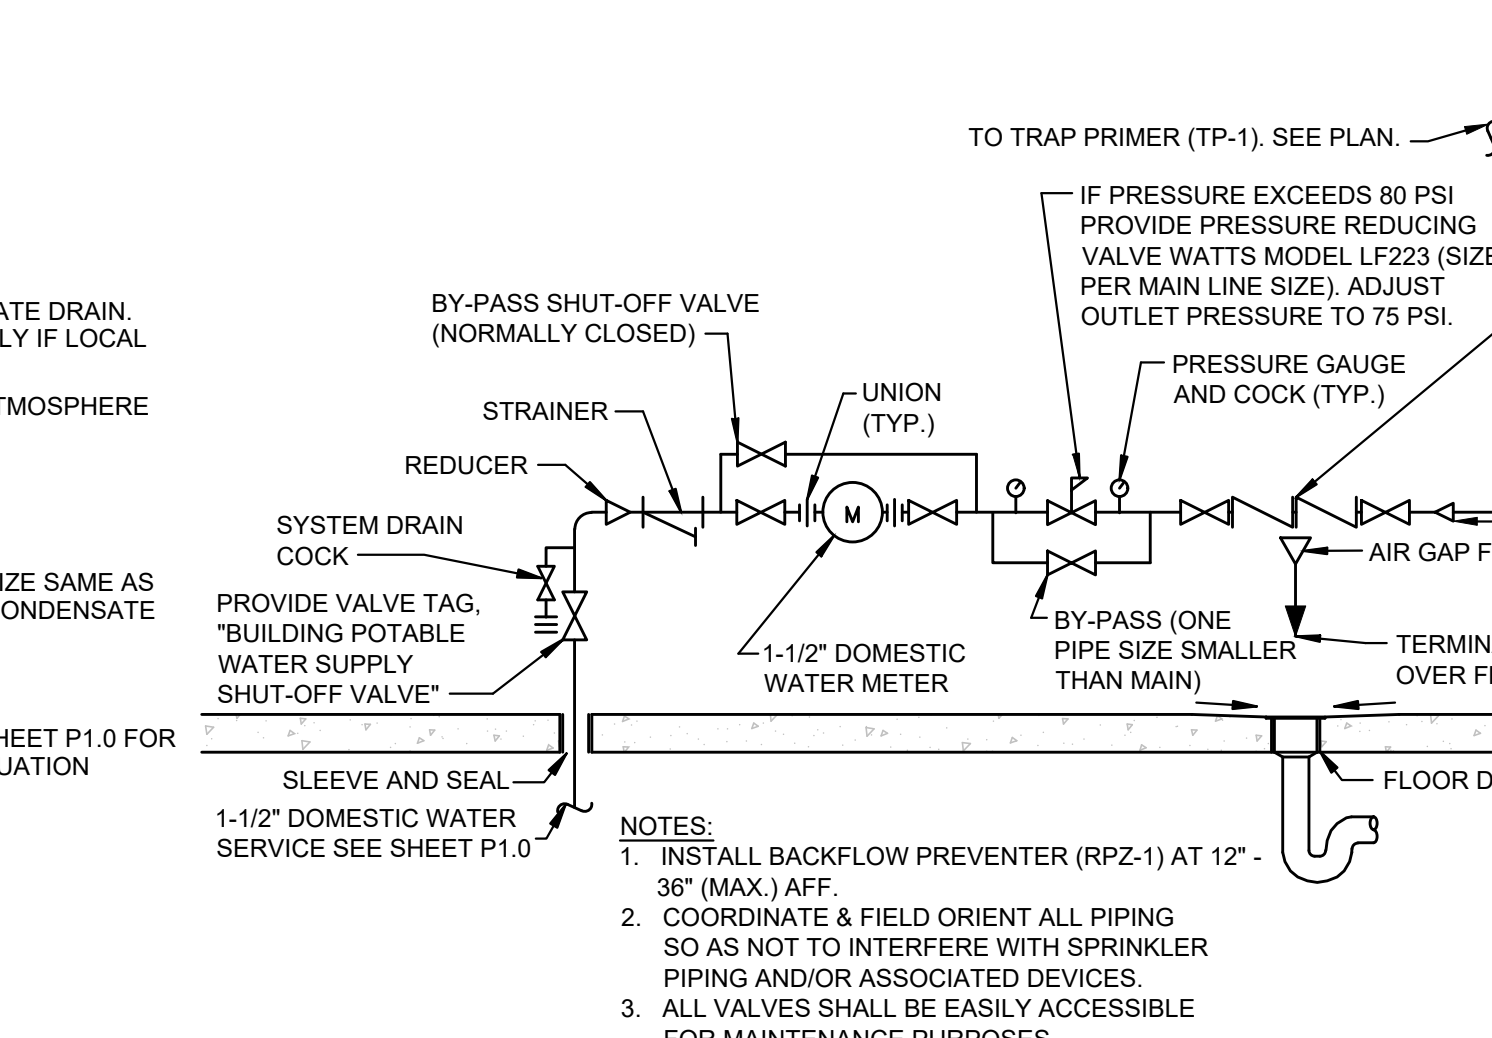

4 TYPICAL RTU CONDENSATE PIPING
P2.0 SCALE: N.T.S.

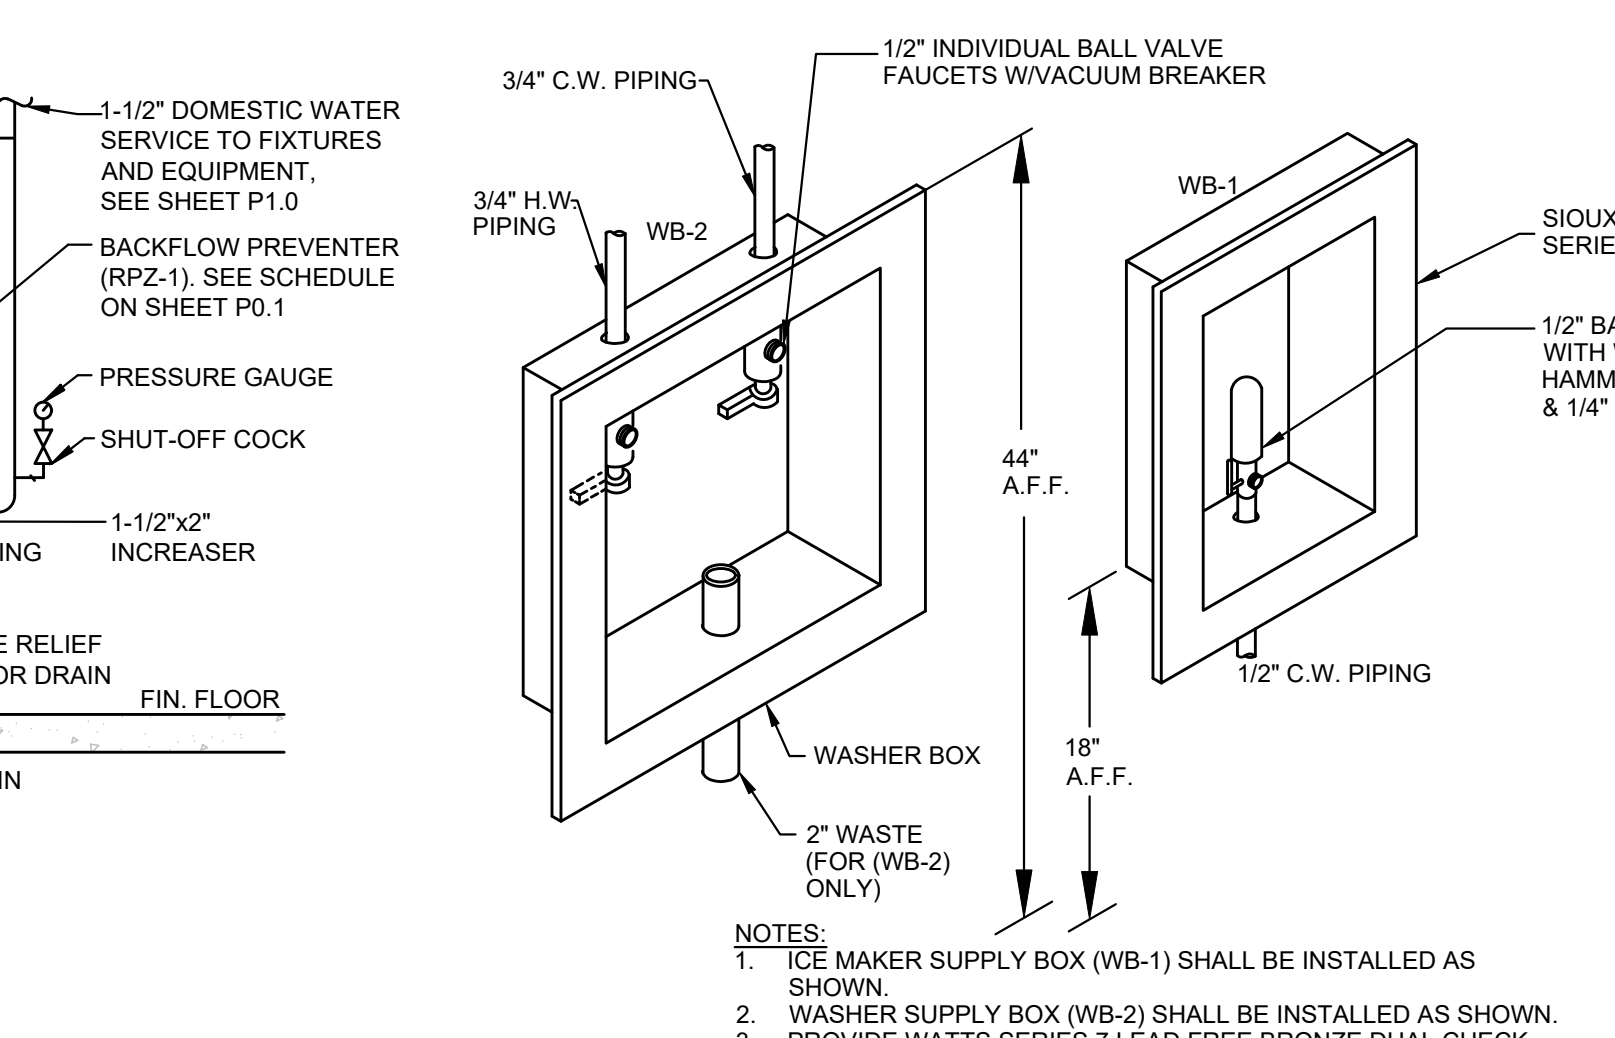

3 DOMESTIC WATER SERVICE ENTRANCE
P2.0 SCALE: N.T.S.

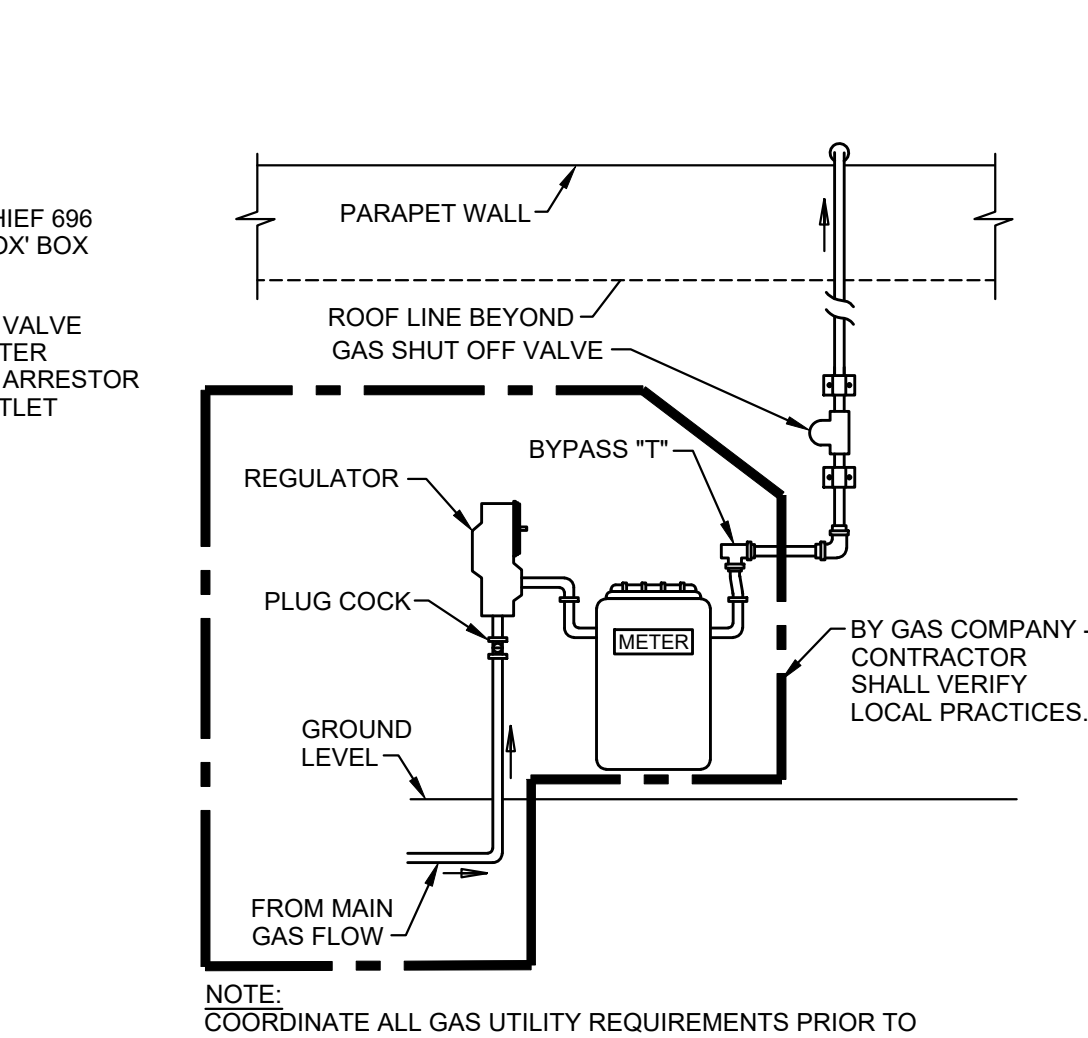

2 WATER SUPPLY BOX (WB-1+WB-2)
P2.0 SCALE: N.T.S.

19601 North 27th Avenue
Phoenix, Arizona 85027 - (623) 580-6100

TENANT:

PROJECT:

ARCHITECT:

CONSULTANT:

SEAL:

CITY SEAL:

DISCLAIMER:

ISSUED FOR:

PROJECT NO:

ORIGINAL SCALE:

DRAWN BY:

CHECKED BY:

PAGE #:

SUBLINE:

TITLE:

SHEET NUMBER:

18K 2025 U.S. VET SERVICES INSTRUCTION SET

FEBRUARY 12, 2025

18K 2025 US INSTRUCTION SET

AS INDICATED

XXX

XXX

01 OF 56

PLUMBING

PLUMBING DETAILS

P2.0