

1. **GENERAL NOTES:**
  - 1. THIS IS A CONCEPT DRAWING ONLY AND IS INTENDED TO REPRESENT AREAS WHERE WATER LINES, SPRINKLER LINES, ELECTRICAL CONDUITS AND H.V.A.C. DUCTWORK RUNS ARE TO BE ROUTED.
  - 2. IT REMAINS EACH CONTRACTORS RESPONSIBILITY TO COORDINATE ROUTING OF LINES, ELECTRICAL CONDUIT WITH OTHER TRADES TO INSURE A COMPLETE INSTALLATION.
  - 3. HOLD ELECTRICAL CONDUIT TIGHT AS POSSIBLE TO TOP CHORD OF JOISTS.
  - 4. **ALL EQUIPMENT, WATER LINES, CEILING GRID, H.V.A.C. DUCTWORK, ROOF LEADER PIPING, CONDUITS, LIGHT FIXTURES, AND FIRE SPRINKLER LINES MUST BE SUSPENDED FROM THE JOISTS ONLY. DO NOT LAY ALONG THE BOTTOM CHORD OF JOISTS OR SUSPEND FROM THE ROOF DECK.**
  - 5. H.V.A.C. DUCTWORK TO BE INSTALLED IN JOIST SPACE ON CERTAIN PROJECTS. BOTTOM OF DUCTWORK TO BE ABOVE BOTTOM OF JOIST. VERIFY WITH MECHANICAL SHEETS FOR EACH PROJECT FOR SPECIFIC REQUIREMENTS AND EXACT LOCATION OF DUCTWORK.
2. THIS DETAIL TO BE DISTRIBUTED TO ALL CONTRACTORS INSTALLING WORK LISTED.
3. PIPING AND OR CONDUIT PENETRATING WALLS, IN CUSTOMER AREAS, SHALL BE CONCEALED IN ADJACENT METAL STUD WALLS OR BOXED OUT, TO BE HIDDEN FROM CUSTOMER VIEW. ALL PENETRATIONS ARE TO BE AS SMALL AS POSSIBLE AND BE APPROVED BY ARCHITECT AND OWNER PRIOR TO INSTALLATION.

|                                                                                     |                                                                                                                                       |
|-------------------------------------------------------------------------------------|---------------------------------------------------------------------------------------------------------------------------------------|
|  | SUSPENDED 8' LED LIGHT<br>@14'-0" OR 12'-0" AFF (REFER TO ELECTRICAL)                                                                 |
|  | WALL MOUNTED 4' LED LIGHT<br>@96" OR 108" AFF (REFER TO ELECTRICAL)                                                                   |
|  | 2X2 LED LIGHT IN T-BAR CEILING                                                                                                        |
|  | CEILING MOTION SENSOR                                                                                                                 |
|  | CANOPY POT LIGHTS                                                                                                                     |
|  | EXTERIOR WALL MOUNTED FIXTURE                                                                                                         |
|  | EMERGENCY EXIT SIGNAGE - LOCATE AND MOUNT PER CITY AND FIRE MARSHALL REQUIREMENTS<br>COORDINATE WITH ELECTRICAL, WALL MOUNT AT DOORS. |
|  | EMERGENCY LIGHT HEADS - CEILING MOUNTING                                                                                              |
|  | DC BATTERY UNIT, SEE ELECTRICAL DRAWINGS                                                                                              |
|  | CEILING MOUNTED SPEAKER                                                                                                               |
|  | SUPPLY DIFFUSER                                                                                                                       |
|  | RETURN DIFFUSER                                                                                                                       |
|  | EXHAUST DIFFUSER                                                                                                                      |
|  | 2' x 4' RETURN DIFFUSER                                                                                                               |
|  | LINEAR SLOT DIFFUSER                                                                                                                  |
|  | LOUDSPEAKER                                                                                                                           |
|  | PENDANT MOUNTED SPEAKER                                                                                                               |

|     |                                                                                                                                                                                                     |
|-----|-----------------------------------------------------------------------------------------------------------------------------------------------------------------------------------------------------|
| C-1 | <p>EXPPOSED CONSTRUCTION - PATTERN (P-1)<br/> EXPPOSED DUCTWORK, EXPPOSED GRILLS,<br/> PIPING, STRUCTURE, ETC. TO AND<br/> INCLUDING BOTTOM OF ROOF DECK<br/> "DOVER GRAY" PPG 1001-S (DRYFALL)</p> |
| C-2 | <p>2X4 LAY IN ACoustICAL CEILING PANEL<br/> USG INTERIORS, INC.<br/> PATTERN: RADIAN CLIMAPLUS ILLUSION<br/> 270/24 N4 2842<br/> FINISH: FACTORY PREFINISHED WHITE</p>                              |
| C-3 | <p>2X4 VINYL COATED LAY IN ACoustICAL<br/> CEILING PANEL USG INTERIORS, INC.<br/> PATTERN: SHEETROCK CLIMAPLUS #3270<br/> FINISH: WHITE VINYL FINISH IN STIPPLE<br/> PATTERN</p>                    |
| C-4 | <p>2X4 REINFORCED FIBERGLASS LAY IN<br/> ACoustICAL CEILING PANEL CERTAINTED.<br/> PATTERN: SYMPHONY F 1340-OF-1<br/> FINISH: WHITE OVER COAT</p>                                                   |
| C-5 | <p>EXPPOSED GYPSUM BOARD-PANEL (P-2)<br/> "COMMERCIAL WHITE" PPG1025-1.</p>                                                                                                                         |
| C-6 | <p>BULKHEAD PANEL (P-3), DOVER GRAY<br/> PPG1001-S PPG PANTS.</p>                                                                                                                                   |
| C-7 | <p>FRP FINISH TO MATCH ROOM FINISH, REFER<br/> TO INTERIOR ELEVATIONS</p>                                                                                                                           |

# 16K 2026 U.S. INSTRUCTION SET

**AUGUST 10, 2026**

ARCHITECT:

CONSULTANT

U:

Y SEAL:

CLAIMER:  
THIS DRAWING AND DESIGN IN COPYRIGHT PROTECTED WHICH SHALL NOT BE USED,  
REPRODUCED OR REVISED WITHOUT WRITTEN PERMISSION BY PETSMART. THE  
CONTRACTOR SHALL CHECK AND VERIFY ALL DIMENSIONS AND UTILITY LOCATIONS  
AND REPORT ALL ERRORS AND OMISSIONS PRIOR TO COMMENCING WORK.  
THIS DRAWING IS NOT TO BE SCALED.

LED FOR:

[illegible]

PROJECT NO.

16K 2026 US INSTRUCTION SET

ORIGINAL SCALE:  
AS INDICATED[illegible]

IF THIS BAR IS  
NOT 1" LONG,  
ADJUST YOUR  
PLOT  
SCALE

XXX

DE #:

|  |  |
|--|--|
|  |  |
|--|--|

---

|    |    |
|----|----|
| 11 | 47 |
|----|----|

ARCHITECTURAL


---

---

### ENLARGED REFLECTED CEILING PLAN

EFT NUMBER

### A3.1

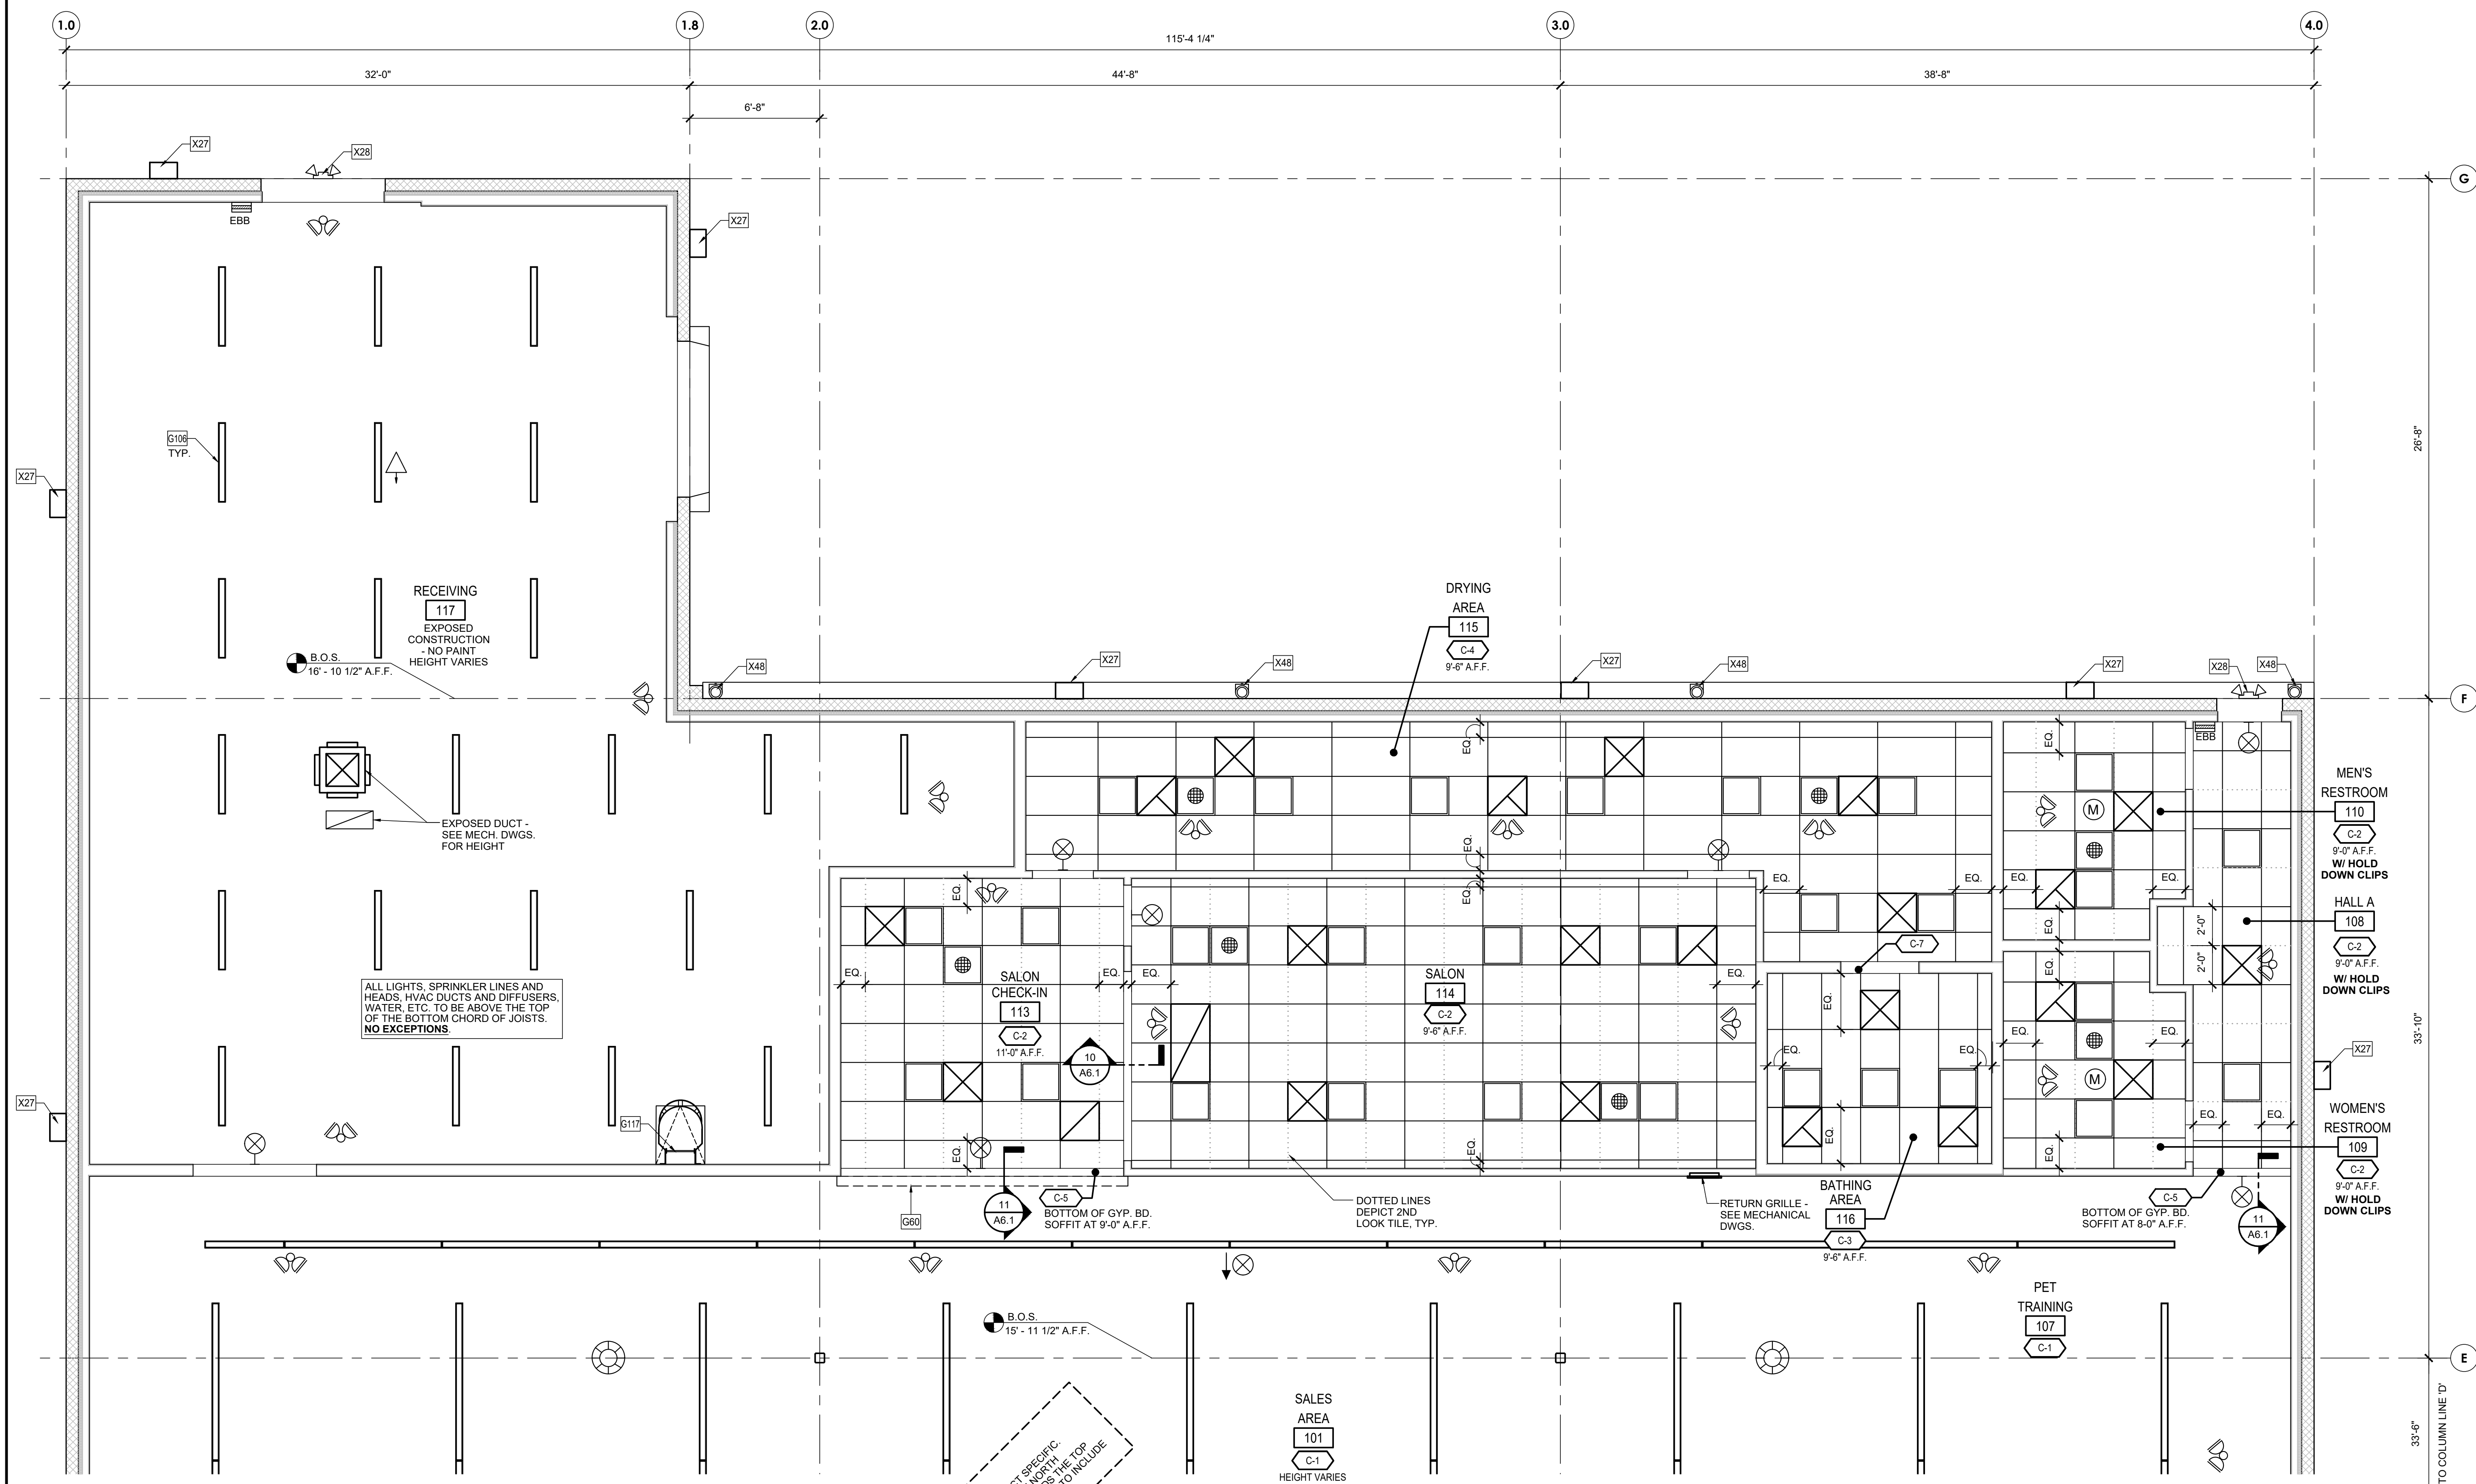

**DESIGNER NOTE:**  
TRUE NORTH TO BE PROVIDED  
REVISE AS REQUIRED. IF  
DIRECTION IS ALREADY TOWARD  
OF THE PAGE THERE IS NO NEED  
FOR "PROJECT NORTH"

1 ENLARGED REFLECTED CEILING PLAN - BACK OF STORE

SCALE: 1/4"=1'-0"

NORTH

A black arrow pointing upwards, enclosed in a circle, with the word "NORTH" written above it.

SALES  
AREA  
101  
C-1  
HEIGHT VARIES