

AUGUST 10, 2026

ARCHITECT

CONSULTA

SEAN

CITY SEAL

DISCLAIMER:

THIS DRAWING AND DESIGN IN COPYRIGHT PROTECTED WHICH SHALL NOT BE USE REPRODUCED OR REVISED WITHOUT WRITTEN PERMISSION BY PETSMART. THE CONTRACTOR SHALL CHECK AND VERIFY ALL DIMENSIONS AND UTILITY LOCATIONS AND REPORT ALL ERRORS AND OMISSIONS PRIOR TO COMMENCING WORK.

THIS DRAWING IS NOT TO BE SCALED.

19915050

[illegible]

PROJECT NO: 16K 2026 US INSTRUCTION SET

ORIGINAL SCALE:
AS INDICATED

DRAWN BY

	CHECKED
--	---------

PAGE #:


Diagnosis

1


ENLARGED SUPPLY FLOOR PLANS

SHEET NO.


M1.1

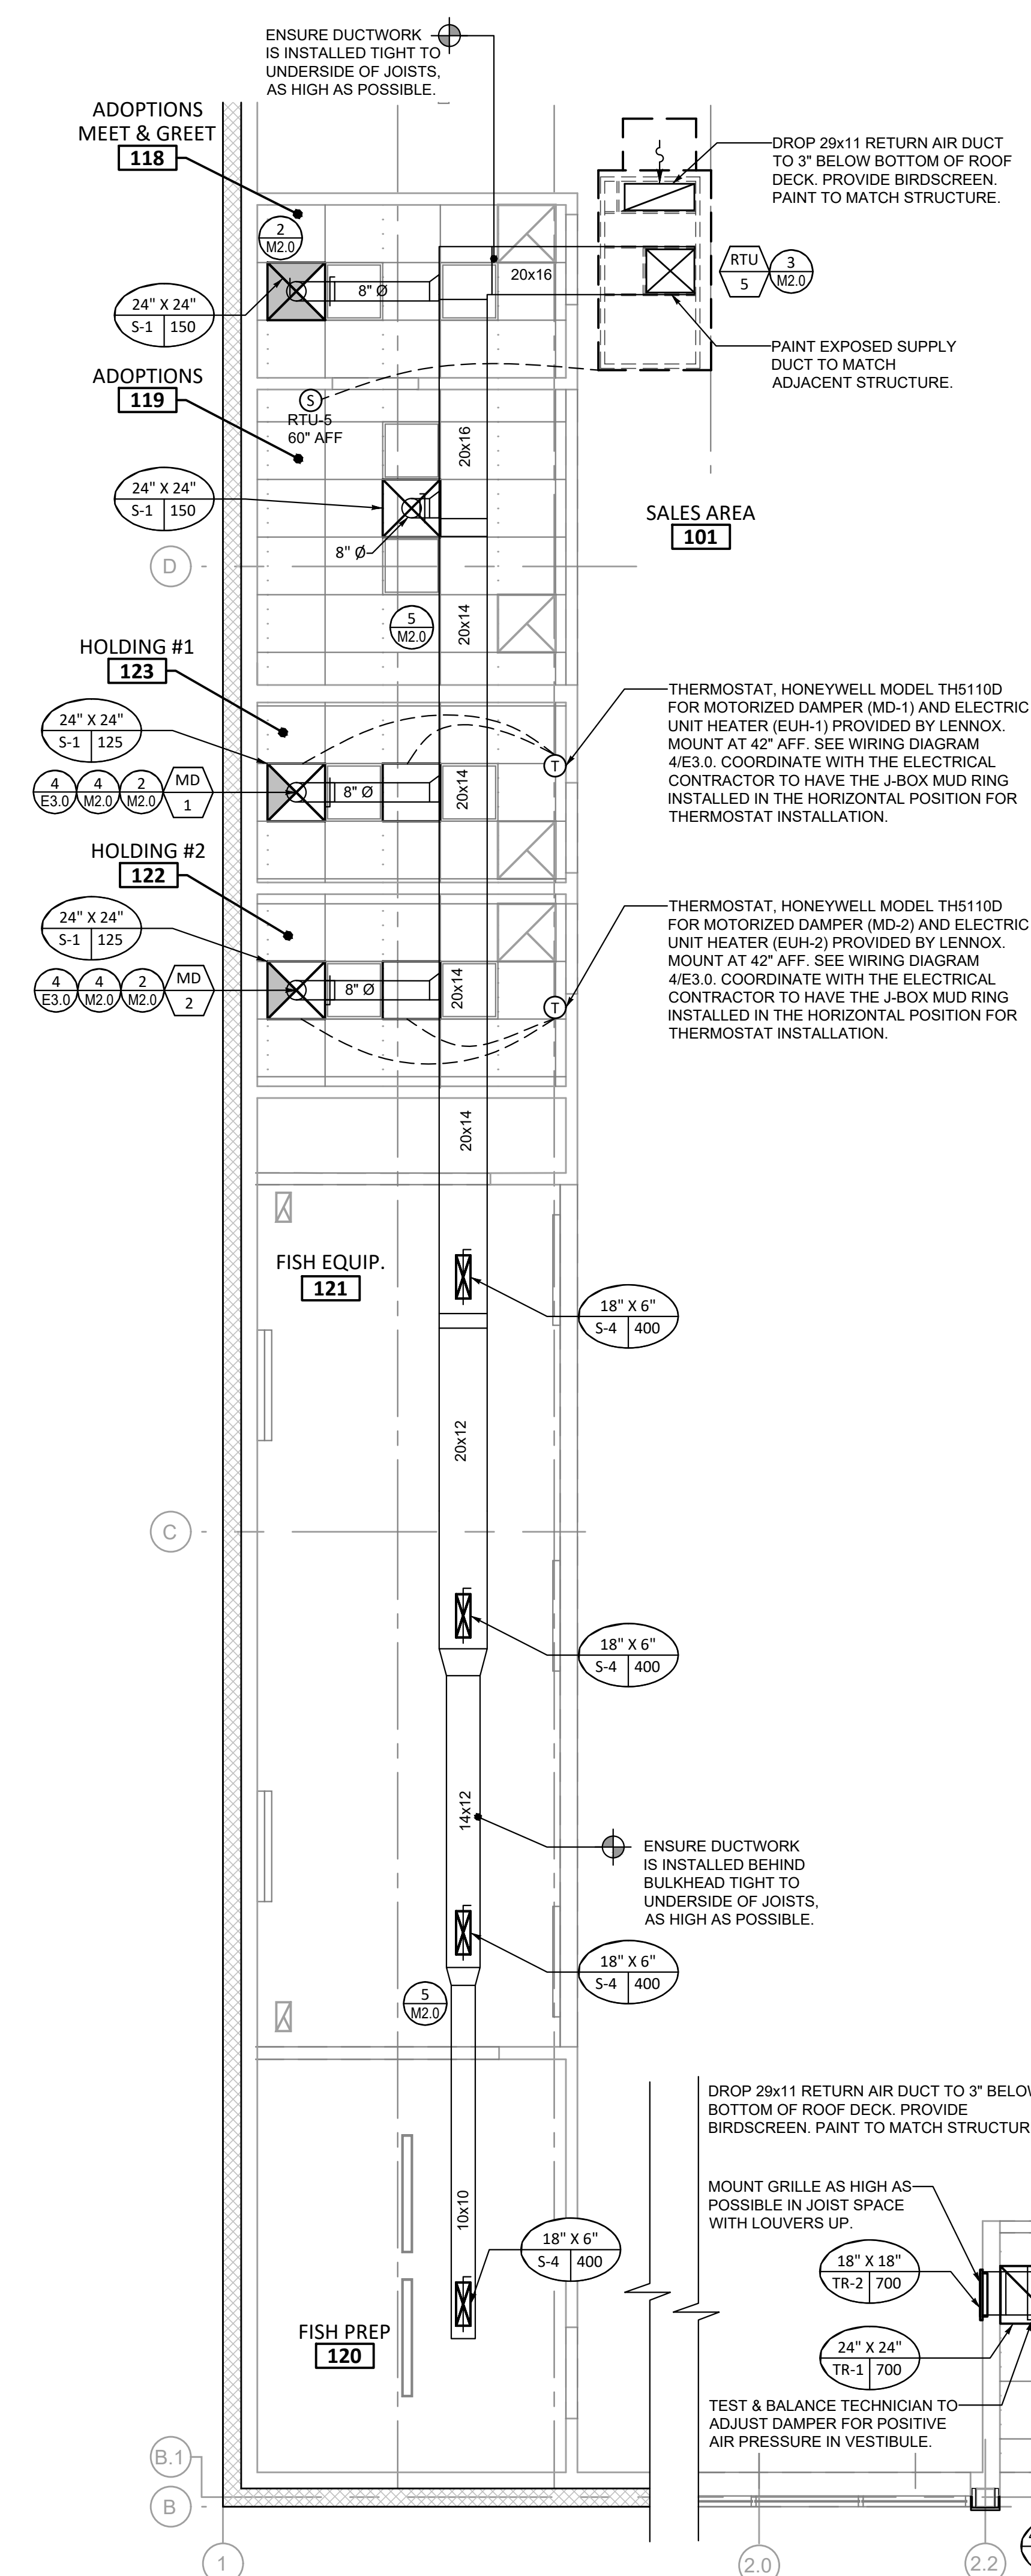

1
M1.1 ENLARGED MECHANICAL FISH EQUIP./
ADOPTIONS/ HOLDING & OFFICE HVAC PLAN
SCALE: 1/4" = 1'-0"

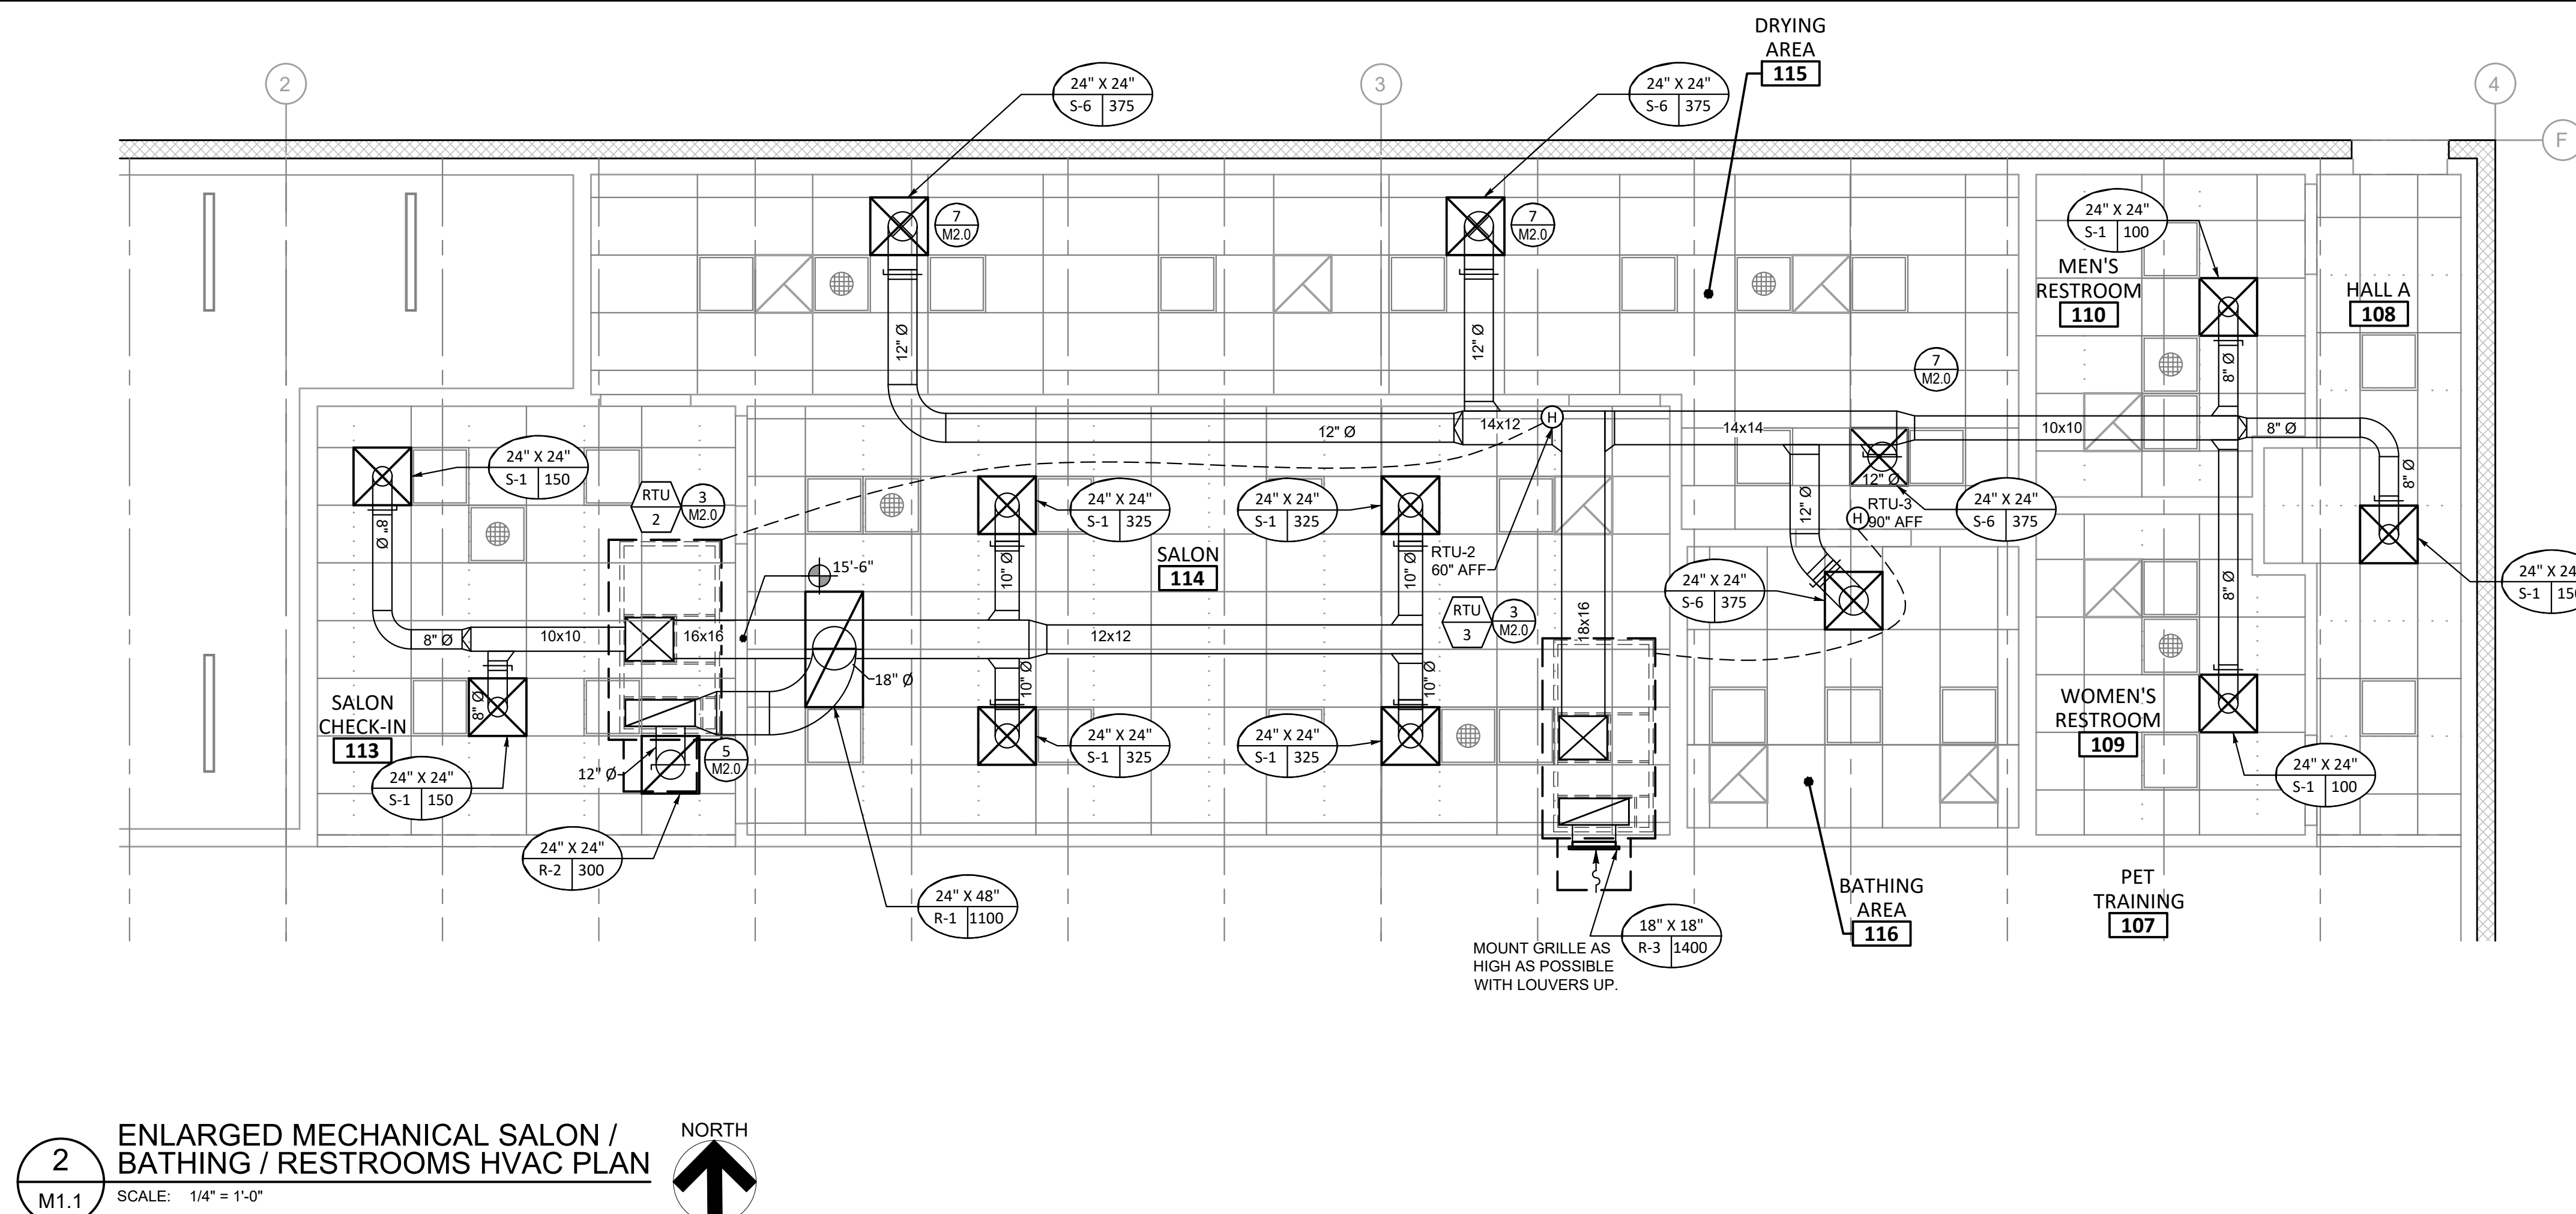

2 ENLARGED MECHANICAL SALON /
BATHING / RESTROOMS HVAC PLAN
M1.1 SCALE: 1/4" = 1'-0"

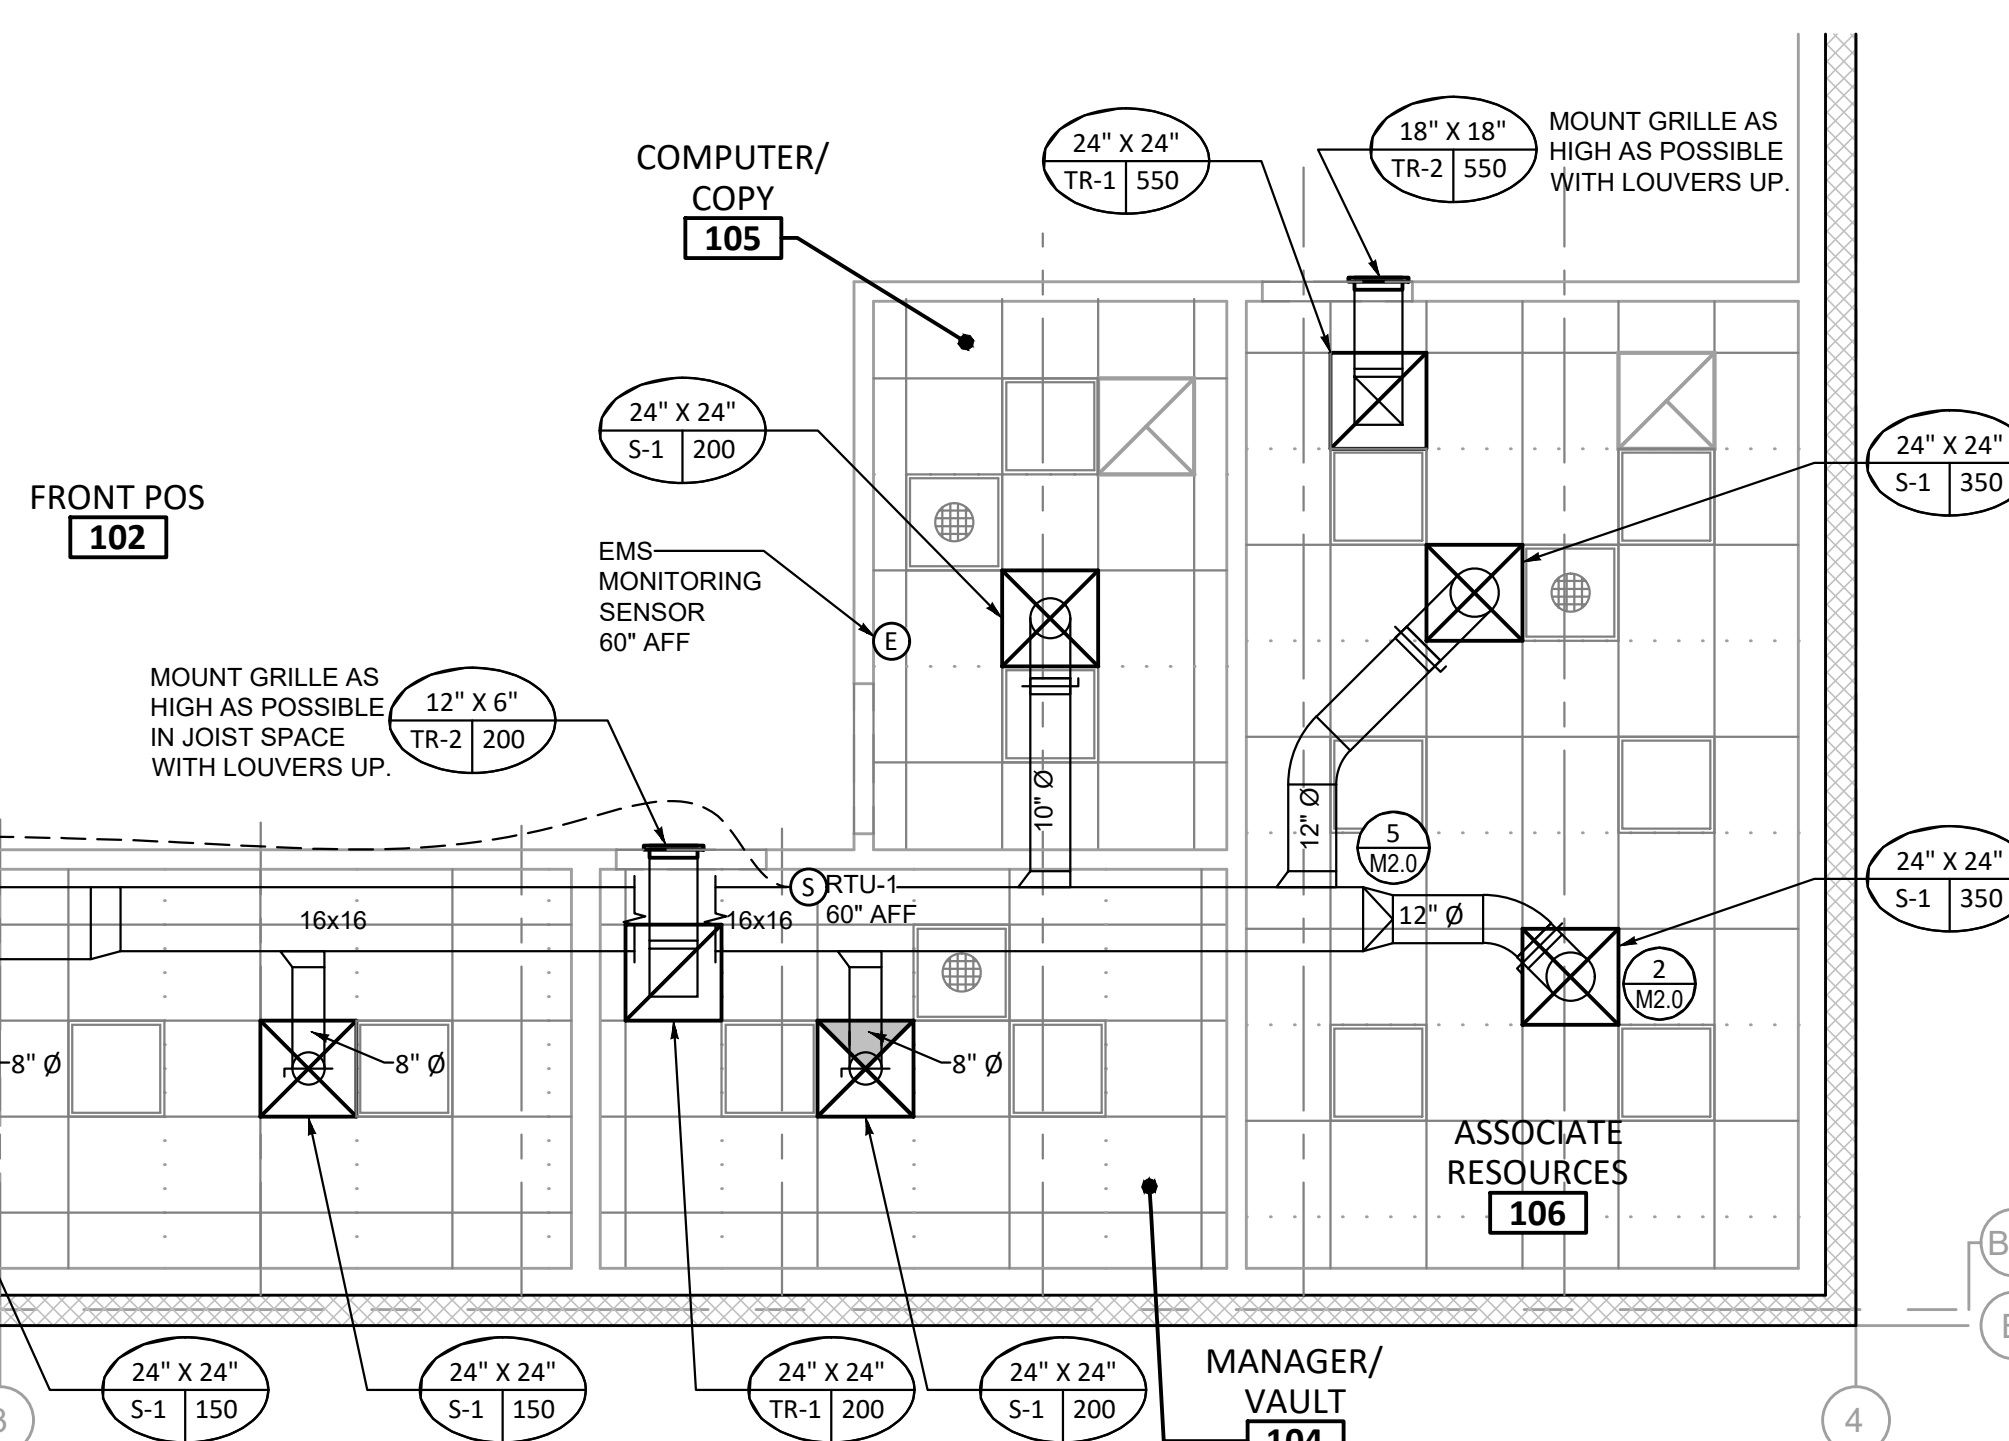

NOTES TYPICAL FOR ALL DUCTWORK

- A. EXPOSED SUPPLY/RETURN DUCTWORK SHALL BE INTERNALLY LINED (NO DUCT WRAP INSULATION FOR EXPOSED DUCTWORK).
- B. ALL CONCEALED SUPPLY AIR DUCTWORK (ABOVE T-BAR CEILINGS) IS TO BE THERMALLY INSULATED, INCLUDING FLEXIBLE SPIRAL DUCTING.
- C. ALL VERTICAL SUPPLY AIR DUCTWORK DROPS FROM THE ROOF TOP UNITS SHALL HAVE A SMOOTH RADIUS BEND TRANSITION TO THE HORIZONTAL DISTRIBUTION.
- D. ALL VOLUME DAMPERS FOR AIR DEVICES SHALL BE INSTALLED TO BE ACCESSIBLE FOR BALANCING. LOCATE WITHIN 24" OF CEILING.
- E. VOLUME DAMPERS SHALL HAVE 1" STAND-OFFS FOR INSULATION THICKNESS.
- F. ALL VOLUME DAMPERS MUST HAVE FLUORESCENT TAPE FLAGGING TO IDENTIFY LOCATIONS FOR BALANCER.
- G. **ALL EQUIPMENT, WATER LINES, CEILING GRID, HVAC DUCTWORK, ROOF LEADER PIPING, CONDUITS, LIGHTING FIXTURES, AND FIRE SPRINKLER LINES MUST BE SUSPENDED FROM THE JOISTS ONLY. DO NOT HANG ALONG THE BOTTOM CHORD OF DECKS, OR SUSPEND FROM THE ROOF**

IF THIS BAR IS
NOT 1" LONG
ADJUST YOUR
PLOTTER
SCALE

1°